


STATISTICS				
Description	Symbol	Avg	Min	Min/Avg
Car Park	+	20 lux	8 lux	0.40
Service Point	+	25 lux	9 lux	0.36

LUMINAIRE SCHEDULE					
Symbol	Label	Qty	Catalog Number	Description	Lamp
	L4	6	FTS.L094.FW.C9	FTS Factor Small 9,000 lm Luminaire c/w Forward Throw Optic on 6m Column	LED C.9000LM - 4000K
	L5	1	2 x FTS.L094.FW.C9	2 x FTS Factor Small 9,000 lm Luminaire c/w Forward Throw Optic on 6m Column	LED C.9000LM - 4000K
	L6	1	FTS.L094.AY.C9	FACTOR SMALL c/w Asymmetric Optic on 6m Conical Column	LED C.9000LM - 4000K

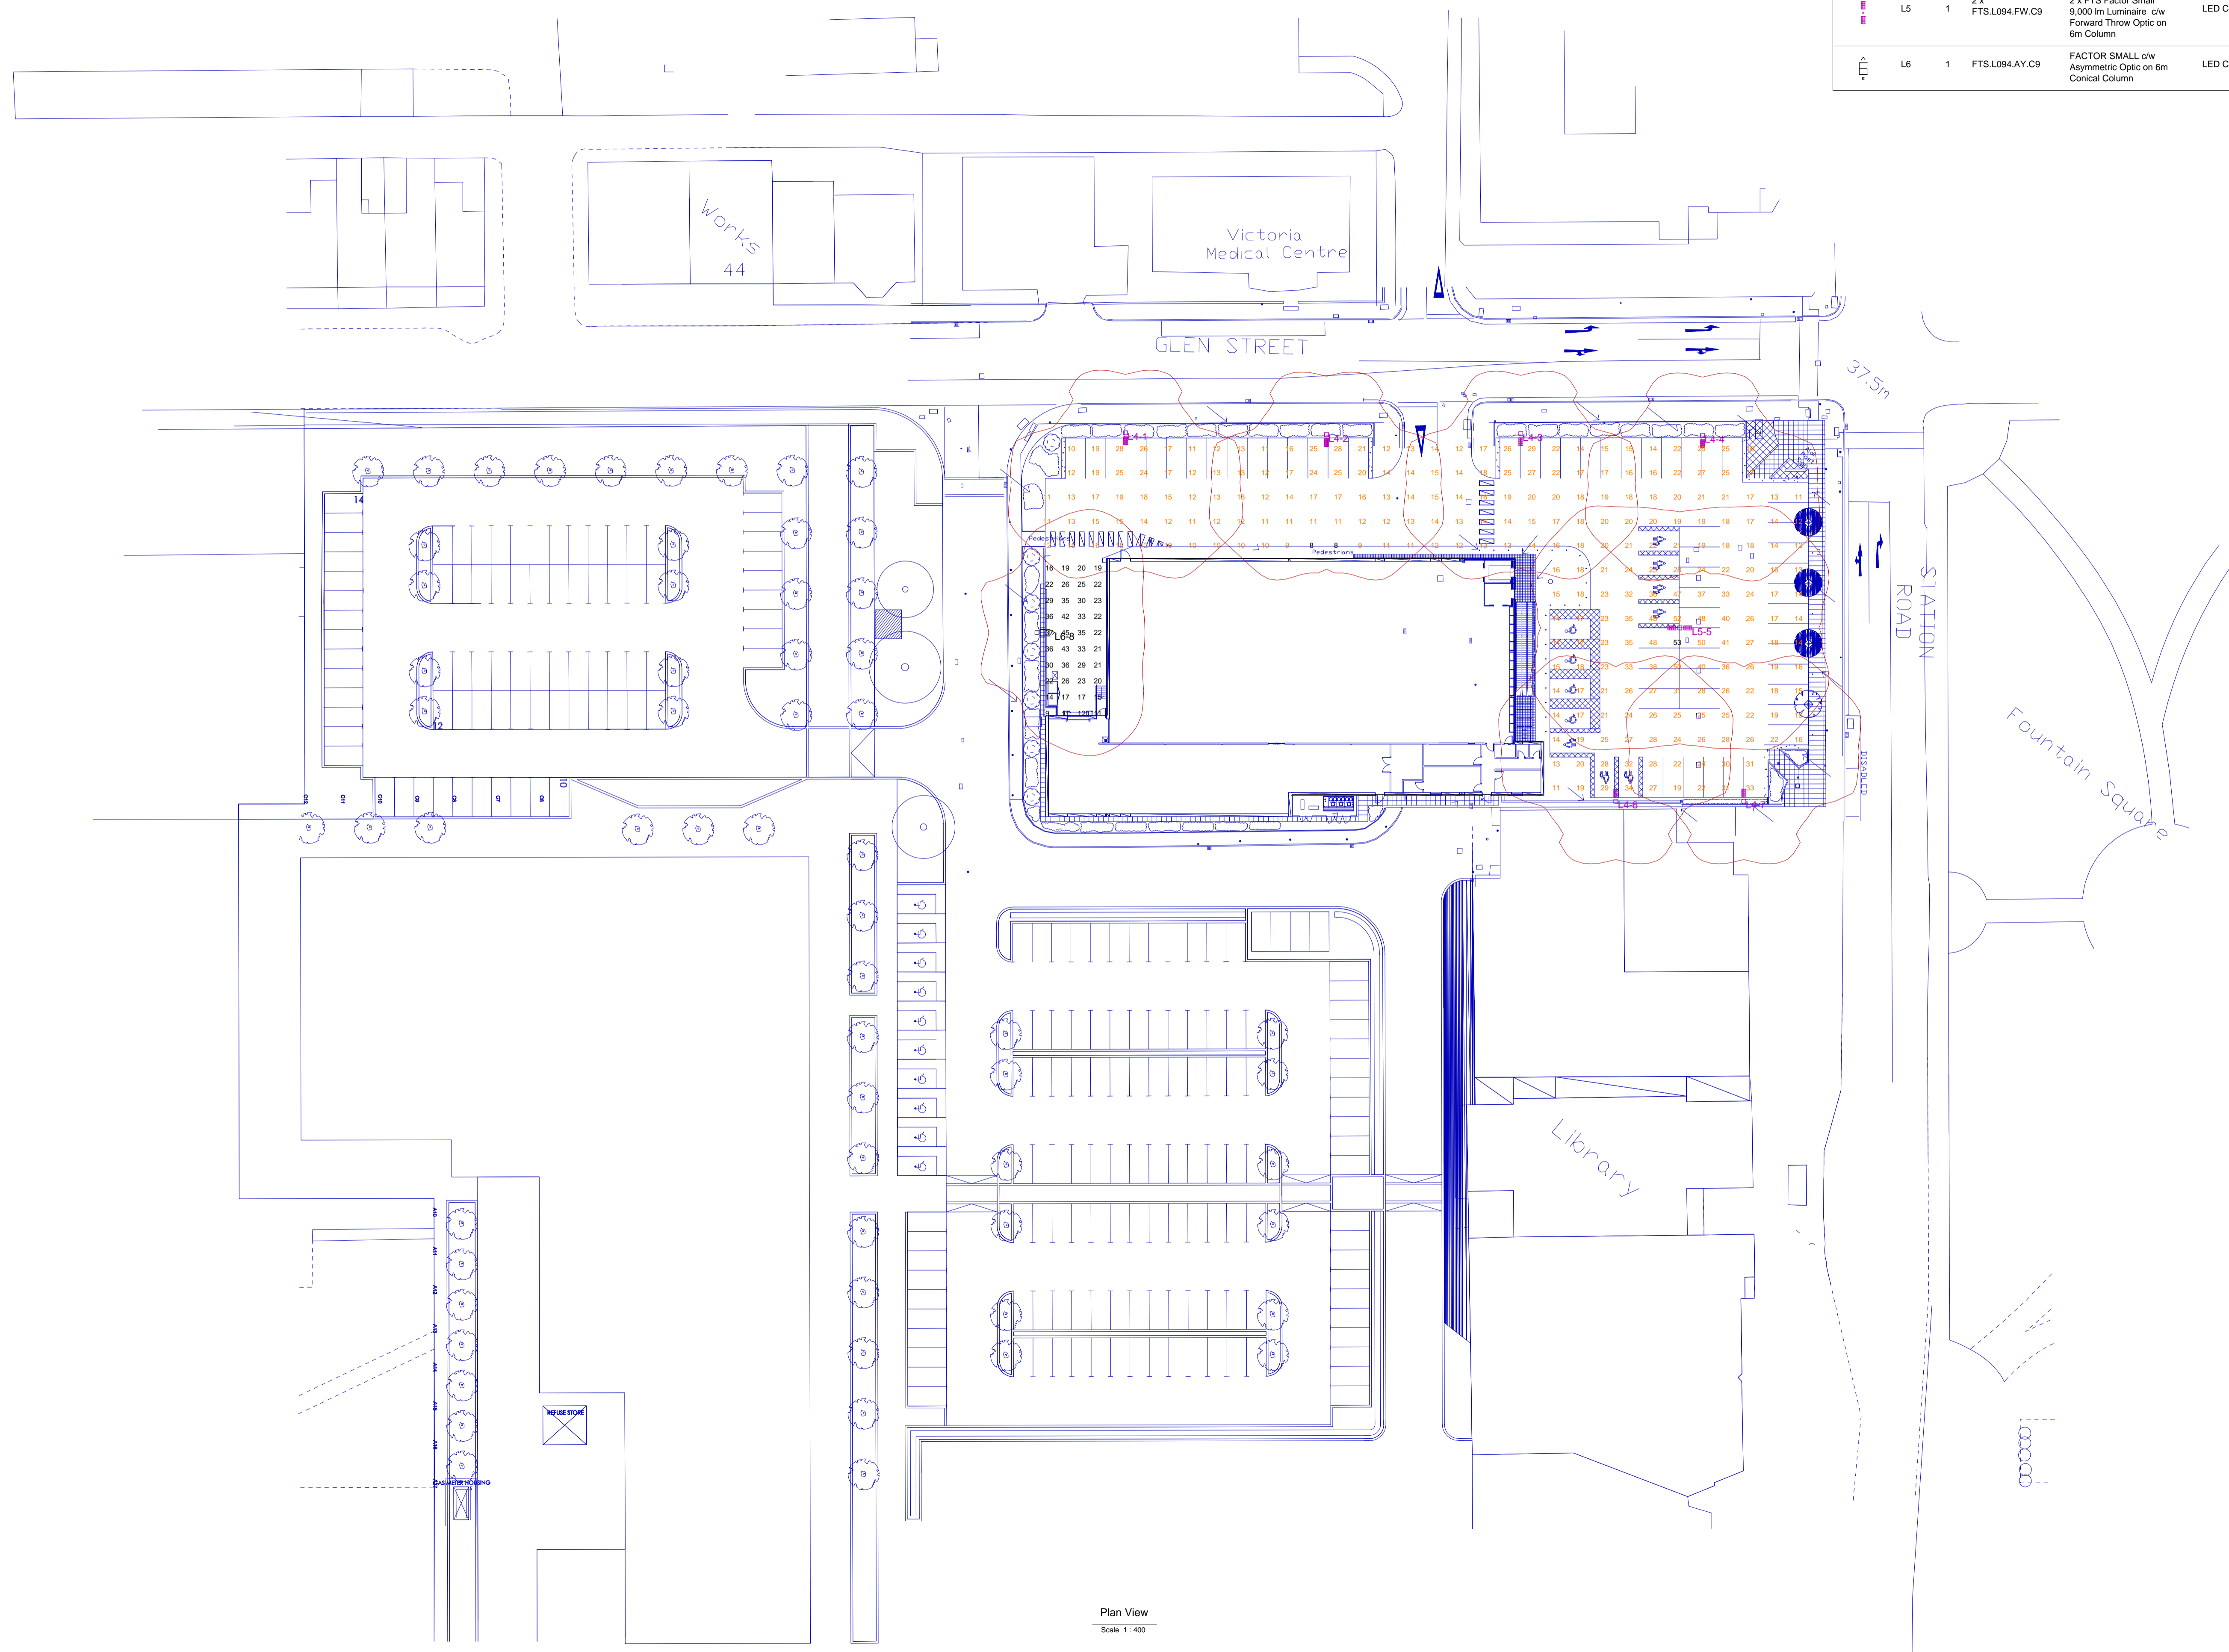

Plan View
Scale 1:400

Aldi Hebburn
Exterior Lighting
Rev 0

Designer	Alan Nicholson
Date	Oct 15th 2015
Scale	1 : 400 @ A1
Drawing No.	Rev 0