



 
SITE LOCATION



NGR E: 438145 N: 563015


Reproduced by permission of Ordnance Survey on behalf of the Controller of Her Majesty's Stationery Office
All rights reserved. © Crown Copyright licence no.: TBC

SITE LOCATION PLAN




1:1250

 SITE AREA PLAN



1:50,000

Reproduced by permission of Ordnance Survey on behalf of the Controller of Her Majesty's Stationery Office
All rights reserved. © Crown Copyright licence no.: TBC

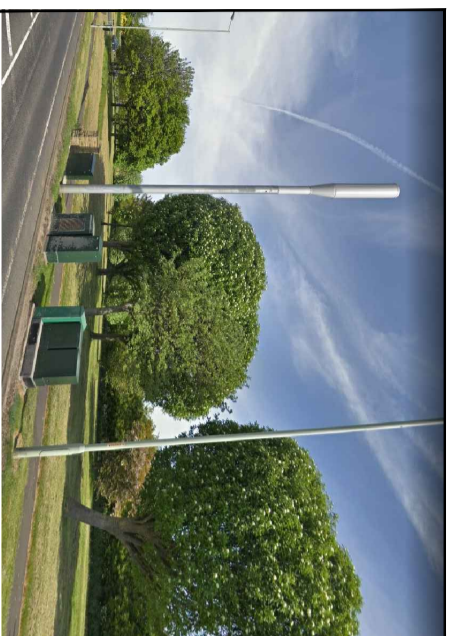

SITE PHOTOGRAPH



GOOGLE MAPS QR CODE

GOOGLE MAPS - Hyperlink to map of the site
GOOGLE STREETVIEW - Hyperlink to streetview of the site

 
NOTES:

1. ALL DIMENSIONS IN MM UNLESS OTHERWISE NOTED.

DIRECTIONS TO SITE:

FROM JUNCTION 3 ON A194M (WHITE MARE POOL)
FOLLOW LEAM LN/A194 AND JOHN REID RD/A1300 TO WHITELEAS
WAY/B1298 IN SOUTH SHIELDS. TAKE NEWNSON AVE TO SHIELDS
RD/A1018. AT THE ROUNDABOUT TAKE THE 2ND EXIT ONTO
SHIELDS RD/A1018 AND SITE IS SITUATED ON THE LEFT SIDE OF
THE ROAD.

Site Provider's
Property Boundary:
Access Route To Site:
Access Route:



Number	MBNL Ref / Title	Project	Purpose of Issue	Issue
M003	03072020	H3G UNILATERAL SW	Planning	C
Drawn:	A. Taylor	Reviser / Upgrade Description		
Checked:	A. Dobson	Tx & Antenna CA's Correlated on Dependencies, Cabinets updated. Existing Cabinets Removed from 266, G1900/U2100		
Approved:	A. Dobson	Feeders revised to 550		
Master:	MBNL / EE / H3G	Project		
M002	MBNL	H3G UNILATERAL SW	Planning	B
Date:	12/08/2020	Reviser / Upgrade Description		
Drawn:	A. Taylor	Mtd Cabinet revised to remain & Cam relocated.		
Checked:	A. Dobson			
Approved:	A. Dobson			
Master:	MBNL / EE / H3G	Project		
M001	MBNL	H3G UNILATERAL SW	Planning	A
Date:	22/05/2020	Reviser / Upgrade Description		
Drawn:	A. Taylor	First Issue - Site nomination dated: TBC		
Checked:	A. Dobson			
Approved:	A. Dobson			



Hutchison 3G UK Limited
Shearwater, 20 Overhill Road
Manchester, M20 5AG
Tel: 0161 785 4500 Fax: 0161 785 4501
Web: www.clarke-telecom.com



Mobile Broadband Network Limited
Sikh Floor, Thames Tower, Station Road, Reading, RG1 1LX




Unit E, Madison Place, Northampton Road,
Manchester, M40 5AG
Tel: 0161 785 4500 Fax: 0161 785 4501
Web: www.clarke-telecom.com

Site Name:	NEAR LAMP 1724 (P95881)		
Site ID:	769681		
Address:	NEAR LAMP 1724 NORTH VERGE SHIELDS ROAD (A1018) CLEADON, SUNDERLAND SR6 7PX		
Title:	002 SITE LOCATION PLAN		
Project:	H3G UNILATERAL SW		
Purpose of Issue:	PLANNING		
EE Call ID:	MBNL Call ID:	3UK Call ID:	Issue:
74020	STY008	SR0080	C
Master Drawing No:	769681_STY008_74020_SR0080_M003		

10mm 50mm 100mm



10mm 50mm 100mm

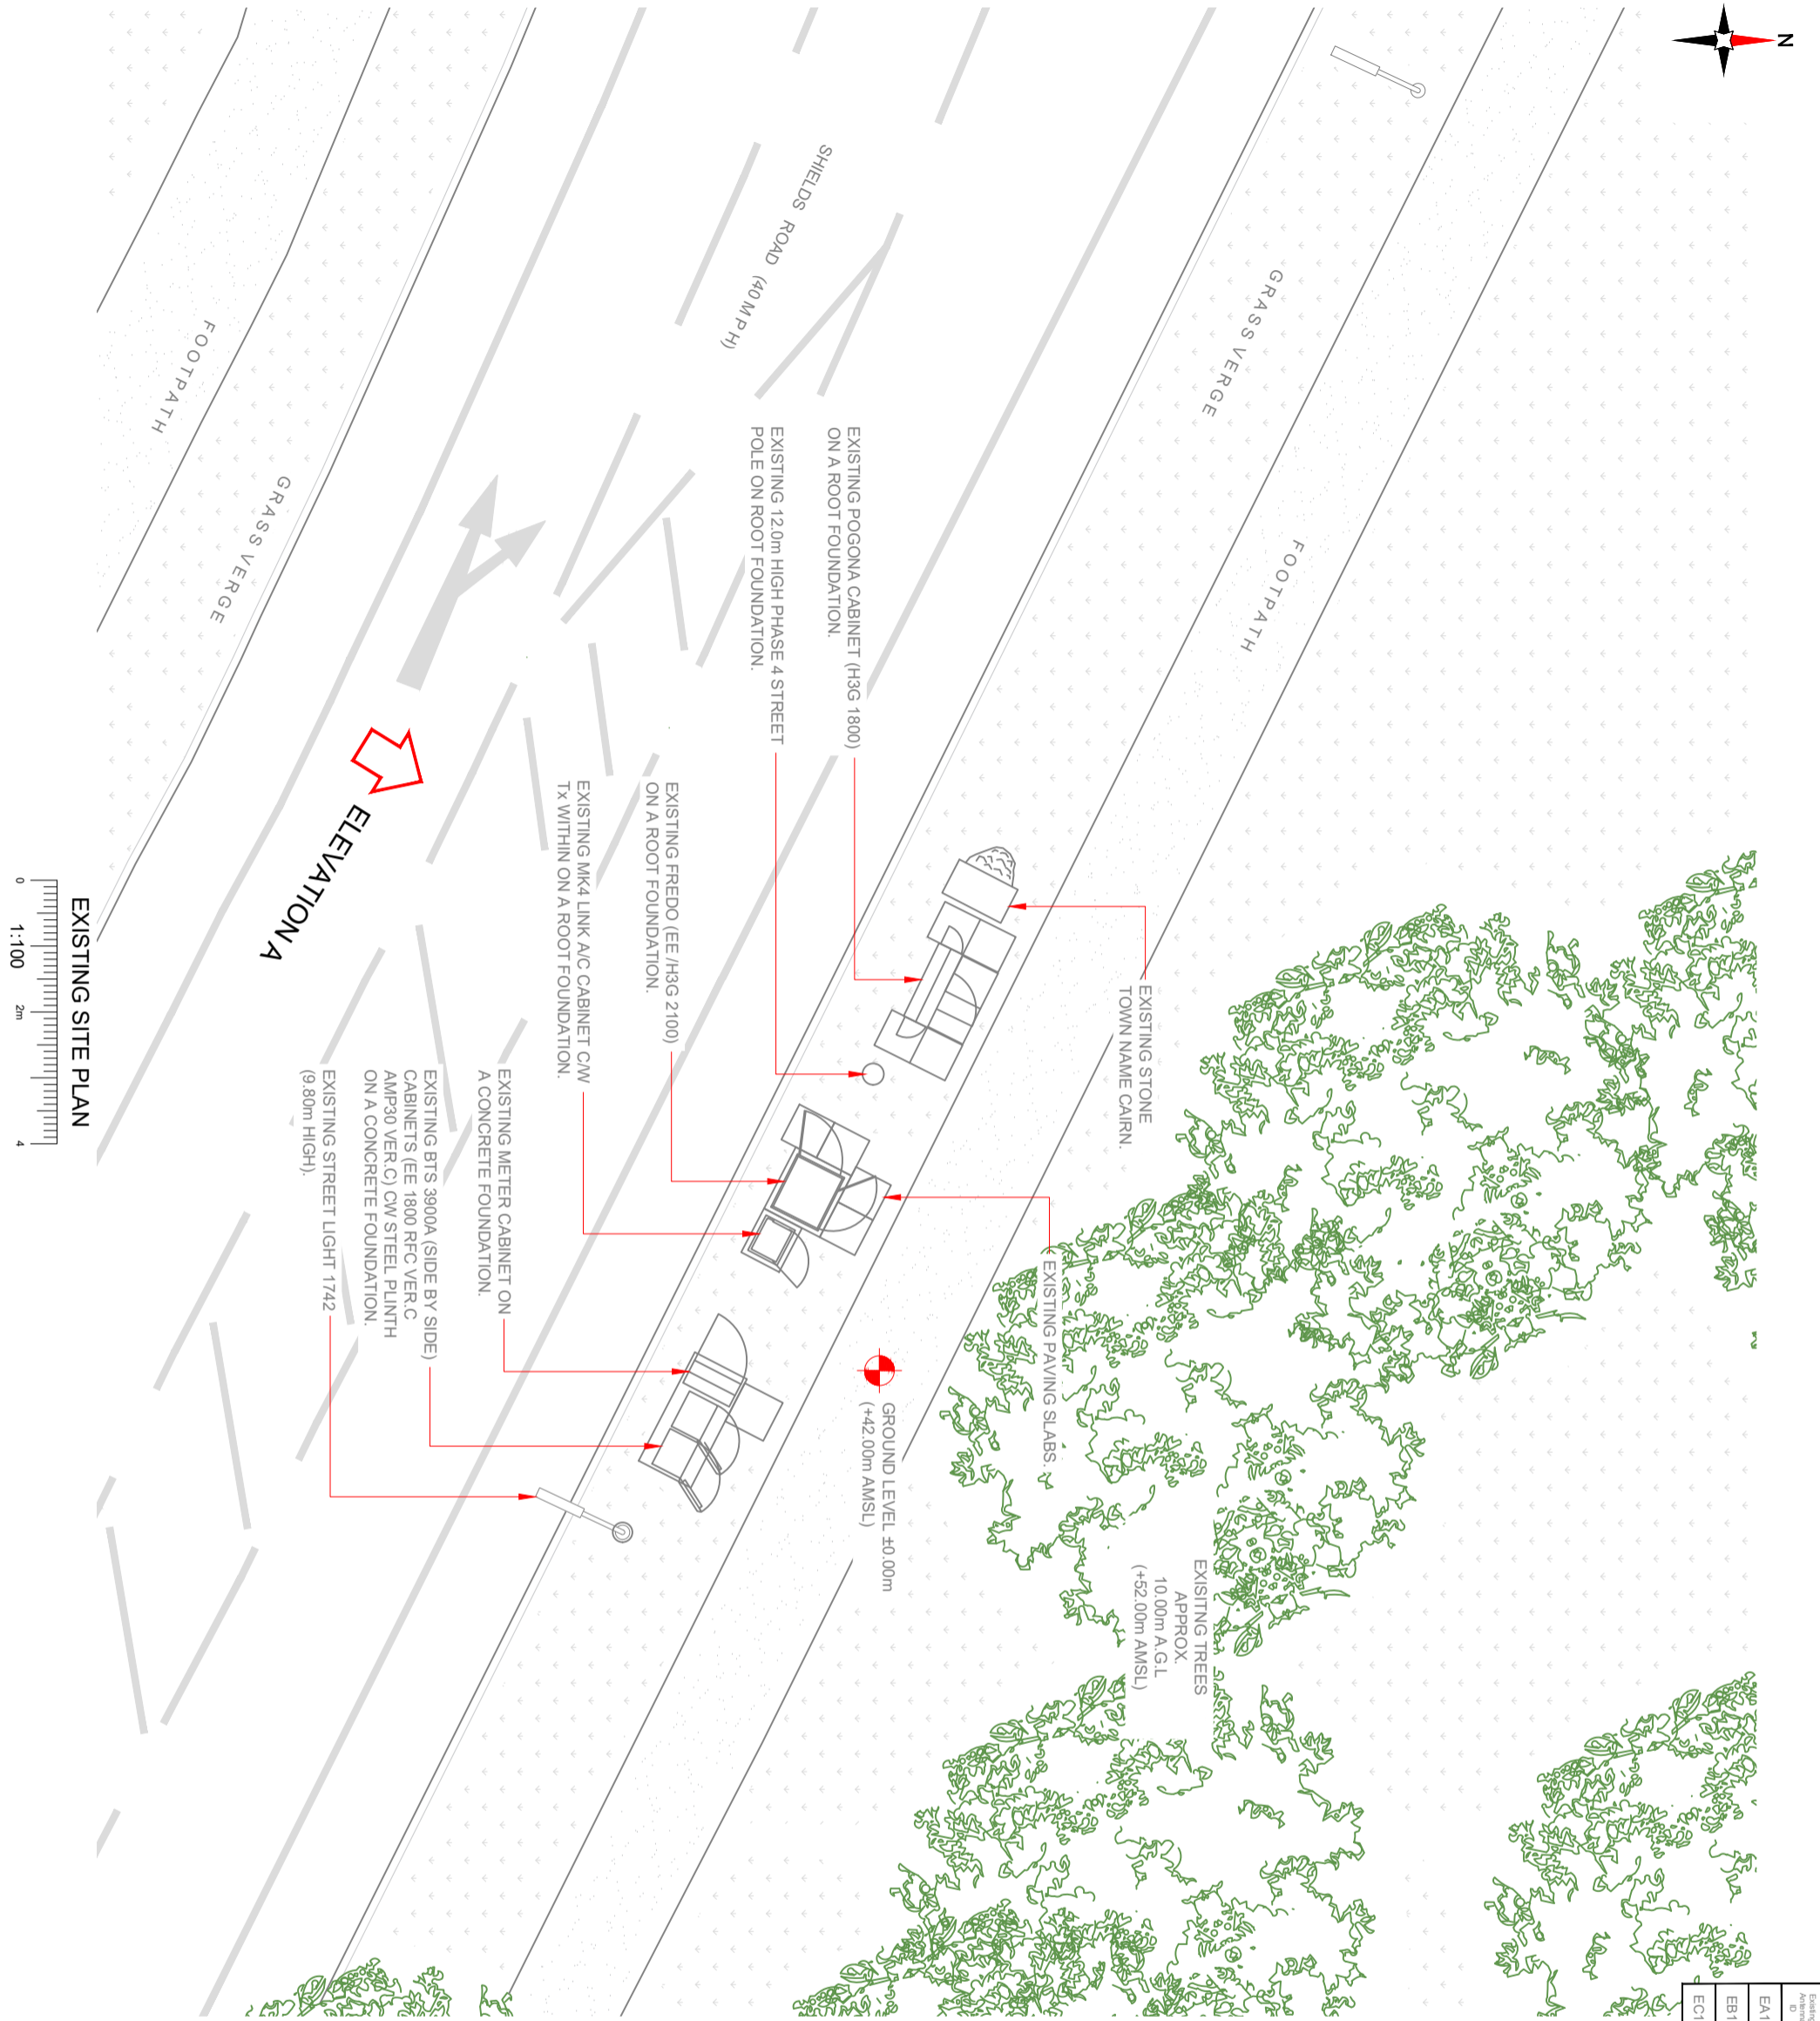

ELEVATION A

EXISTING SITE PLAN
1:100

Existing Drawing No.	Existing Drawing Scale
EA1	30°
EB1	150°
EC1	270°

NOTES:
1. ALL DIMENSIONS IN MM UNLESS OTHERWISE NOTED.

Number	MBNL/EE/H3G	Project	Purpose of Issue	Issue
M003	MBNL	H3G UNILATERAL SW	Planning	C
Date:	03/07/2020	Revision / Upgrade Description		
Drawn:	A. Taylor	Tx & Antenna CA's Correlated on Dependencies, Cabinets updated. Existing Cabinets Removed from 296, G1900U2100		
Checked:	A. Dobson	Feeders revised to 550		
Approved:	A. Dobson			
Number	MBNL/EE/H3G	Project	Purpose of Issue	Issue
M002	MBNL	H3G UNILATERAL SW	Planning	B
Date:	12/08/2020	Revision / Upgrade Description		
Drawn:	A. Taylor	Mtd Cabinet revised to remain & Cairn relocated.		
Checked:	A. Dobson			
Approved:	A. Dobson			
Number	MBNL	Project	Purpose of Issue	Issue
M001	MBNL	H3G UNILATERAL SW	Planning	A
Date:	22/05/2020	Revision / Upgrade Description		
Drawn:	A. Taylor	First Issue - Site nomination dated. TBC		
Checked:	A. Dobson			
Approved:	A. Dobson			

Hutchison 3G UK Limited
Shearwater, 20 Queen Road
Manchester, M4 5AG
Tel: 0161 785 4500 Fax: 0161 785 4501
Web: www.clarke-telecom.com

Field Business Park
Hatfield
Hertfordshire
AL10 9BW
Tel: 01707 315000
Fax: 01707 319001

MBNL Mobile Broadband Network Limited
Sixth Floor, Thames Tower, Station Road, Reading RG1 1LX

Design Consultant & Principal Contractor:

Unit E, Madison Place, Northampton Road,
Manchester, M40 5AG
Tel: 0161 785 4500 Fax: 0161 785 4501
Web: www.clarke-telecom.com

Site Name:	NEAR LAMP 1724 (P95881)	
Site ID:	769681	
Address:	NEAR LAMP 1724 NORTH VERGE SHIELDS ROAD (A1018) CLEADON, SUNDERLAND SR6 7PX	
Title:	100 EXISTING SITE PLAN	
Project:	H3G UNILATERAL SW	
Purpose of Issue:	PLANNING	
EE Call ID:	MBNL Call ID:	3UK Call ID:
74020	STY008	SR0080
Master Drawing No:	769681_STY008_74020_SR0080_M003	Issue:
		C

Existing Angle to bearing	30°
EB1	150°
EC1	270°

NOTES:
1. ALL DIMENSIONS IN MM UNLESS OTHERWISE NOTED.

Number:	MBNL/EE/H3G	Project:	H3G UNILATERAL SW	Purpose of Issue:	Planning	Issue:	C
Date:	03/07/2020	Revison / Upgrade Description:					
Drawn:	A. Taylor	Tx & Antenna CA's Correlated on Dependencies, Cabinets updated. Existing Cabinets Removed from 296, G1900/U2100					
Checked:	A. Dobson	Feeders revised to 550					
Approved:	A. Dobson						
Number:	MBNL/EE/H3G	Project:	H3G UNILATERAL SW	Purpose of Issue:	Planning	Issue:	B
Date:	12/08/2020	Revison / Upgrade Description:	Mtd Cabinet revised to remain & Caim relocated.				
Drawn:	A. Taylor						
Checked:	A. Dobson						
Approved:	A. Dobson						
Number:	MBNL	Project:	H3G UNILATERAL SW	Purpose of Issue:	Planning	Issue:	A
Date:	22/05/2020	Revison / Upgrade Description:	First Issue - Site nomination dated. TBC				
Drawn:	A. Taylor						
Checked:	A. Dobson						
Approved:	A. Dobson						

Hutchison 3G UK Limited
 Site Name: 20 Green Road
 Manchester, M40 5AG
 Tel: 0161 785 4500 Fax: 0161 785 4501
 Web: www.clarke-telecom.com

Clarke telecom
 Unit E, Madison Place, Northampton Road,
 Manchester, M40 5AG
 Tel: 0161 785 4500 Fax: 0161 785 4501
 Web: www.clarke-telecom.com

Field Business Park
 Hatfield
 Hertfordshire
 AL10 9BW
 Tel: 01707 315000
 Fax: 01707 319001


MBNL Mobile Broadband Network Limited
 Skin Floor, Thames Tower, Station Road, Reading RG1 1LX

Design Consultant & Principal Contractor:

Site Name: NEAR LAMP 1724 (P95881)
 Site ID: 769681
 Address: NEAR LAMP 1724
 NORTH VERGE
 SHIELDS ROAD (A1018)
 CLEADON, SUNDERLAND
 SR6 7PX

Title: 150 EXISTING ELEVATION A
 Project: H3G UNILATERAL SW
 Purpose of Issue: PLANNING

EE Call ID:	MBNL Call ID:	3UK Call ID:
74020	STY008	SR0080
Master Drawing No:	769681_STY008_74020_SR0080_M003	
	Issue:	C

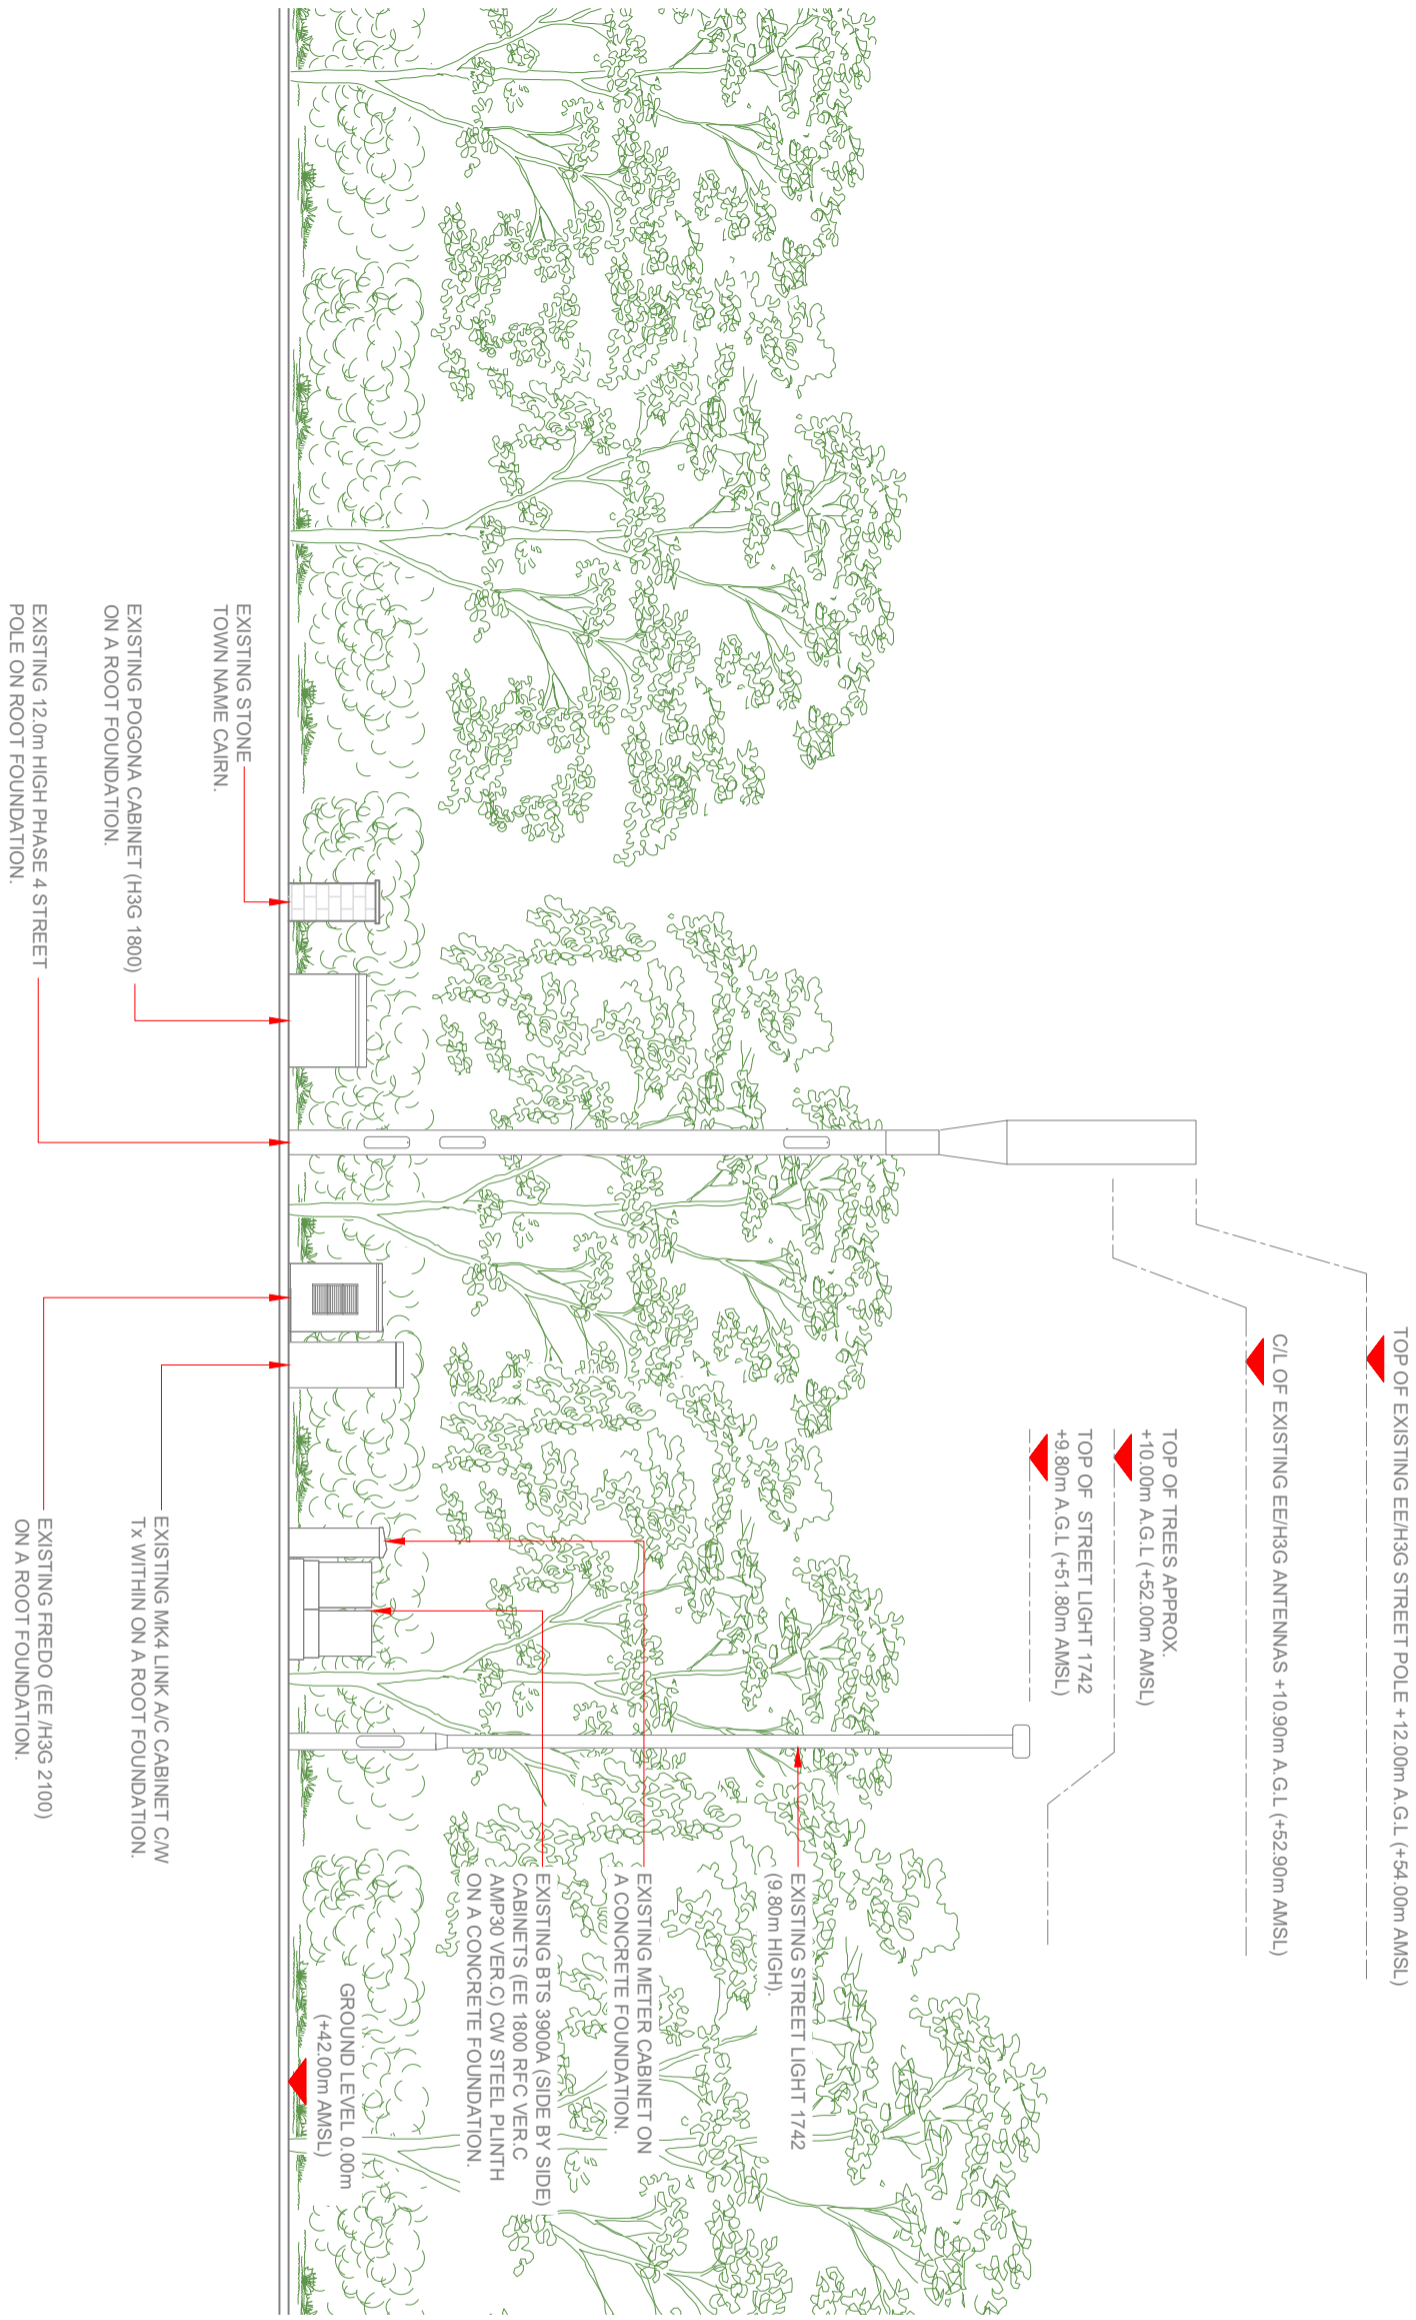


EXISTING ELEVATION A
 0 1:100 2m 4

10mm 50mm 100mm



Antenna Aperture ID	Proposed 4G/5G Bearing	Operator Shared/EE/H3G
A1	30°	H3G
A2	30°	EE/H3G
B1	150°	H3G
B2	150°	EE/H3G
C1	270°	H3G
C2	270°	EE/H3G

NOTES:
1. ALL DIMENSIONS IN MM UNLESS OTHERWISE NOTED.

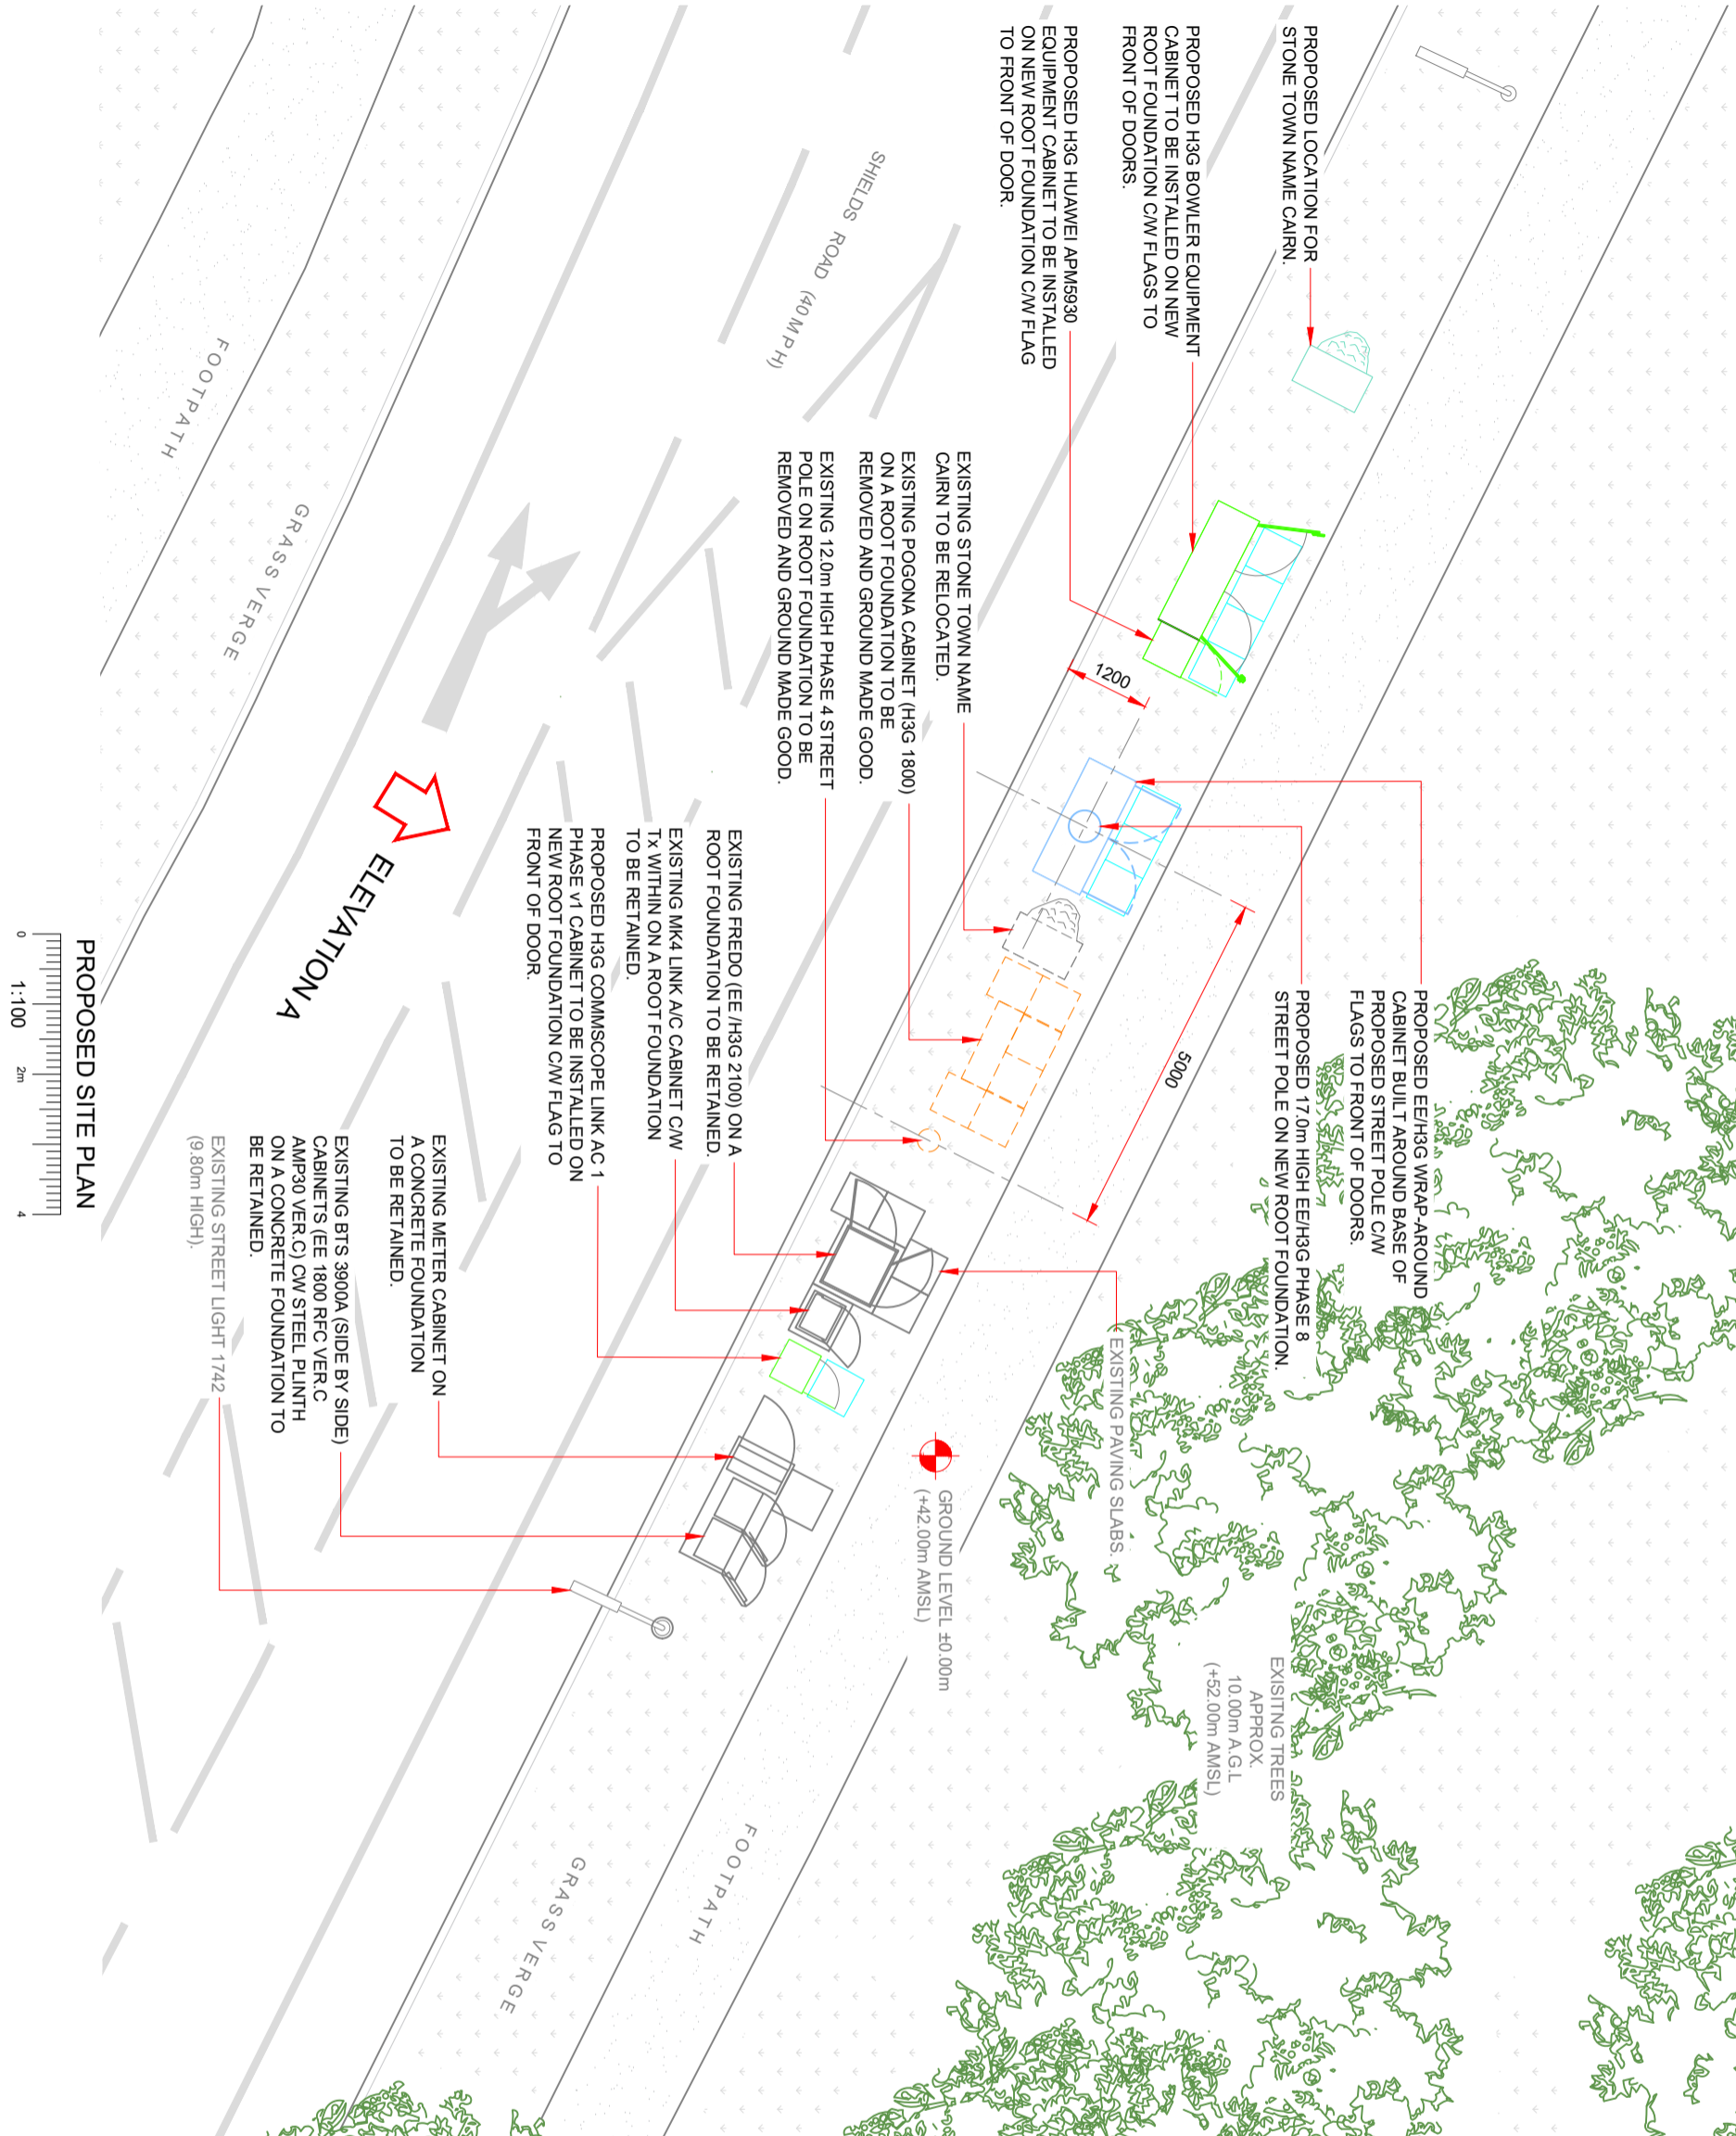

10mm 50mm 100mm

PROPOSED SITE PLAN

0 1:100 2m 4

<p>Number: MBNL/EE/H3G</p> <p>Date: 03/07/2020</p> <p>Drawn: A. Taylor</p> <p>Checked: A. Dobson</p> <p>Approved: MBNL/EE/H3G</p> <p>Number: MBNL</p> <p>Date: 12/08/2020</p> <p>Drawn: A. Taylor</p> <p>Checked: A. Dobson</p> <p>Approved: MBNL/EE/H3G</p>	<p>Project: H3G UNILATERAL SW</p> <p>Revision / Upgrade Description: TY & Antenna CA's, Correlated on Dependencies, Cabinets updated. Existing Cabinets Removed from 296, G1900/U2100 Feeders revised to 550.</p> <p>Project: H3G UNILATERAL SW</p> <p>Revision / Upgrade Description: Mid Cabinet revised to remain & Cairn relocated.</p>	<p>Purpose of Issue: Planning</p> <p>Issue: C</p> <p>Purpose of Issue: Planning</p> <p>Issue: B</p>
<p>Master: MBNL</p> <p>Date: 22/05/2020</p> <p>Drawn: A. Taylor</p> <p>Checked: A. Dobson</p> <p>Approved: A. Dobson</p>	<p>Project: H3G UNILATERAL SW</p> <p>Revision / Upgrade Description: First Issue - Site nomination dated: TBC</p>	<p>Purpose of Issue: Planning</p> <p>Issue: A</p>

Hutchison 3G UK Limited
Shearwater, 20 Queen Road
Manchester, M4 1JH
Tel: 0161 785 4500
Fax: 0161 785 4501
Web: www.h3g.co.uk

EE
Tel: 01707 315000
Fax: 01707 319001

Mobile Broadband Network Limited
Sixth Floor, Thames Tower, Station Road, Reading, RG1 1LX

Unit E, Madison Place, Northampton Road,
Manchester, M40 5AG
Tel: 0161 785 4500 Fax: 0161 785 4501
Web: www.clarke-telecom.com

Design Consultant & Principal Contractor:

Site Name: NEAR LAMP 1724 (P95881)

Site ID: 769681

Address: NEAR LAMP 1724
NORTH VERGE
SHIELDS ROAD (A1018)
CLEADON, SUNDERLAND
SR6 7PX

Title: 215 PROPOSED SITE PLAN



Project: H3G UNILATERAL SW

Purpose of Issue: PLANNING


EE Call ID: 74020	MBNL Call ID: STY008	3UK Call ID: SR0080
Master Drawing No: 769681_STY008_74020_SR0080_M003	Issue: C	

Antenna Aperture ID	Proposed Shared/ Bearing	Operator
A1	30°	H3G
A2	30°	EE/H3G
B1	150°	H3G
B2	150°	EE/H3G
C1	270°	H3G
C2	270°	EE/H3G

NOTES:
1. ALL DIMENSIONS IN MM UNLESS OTHERWISE NOTED.

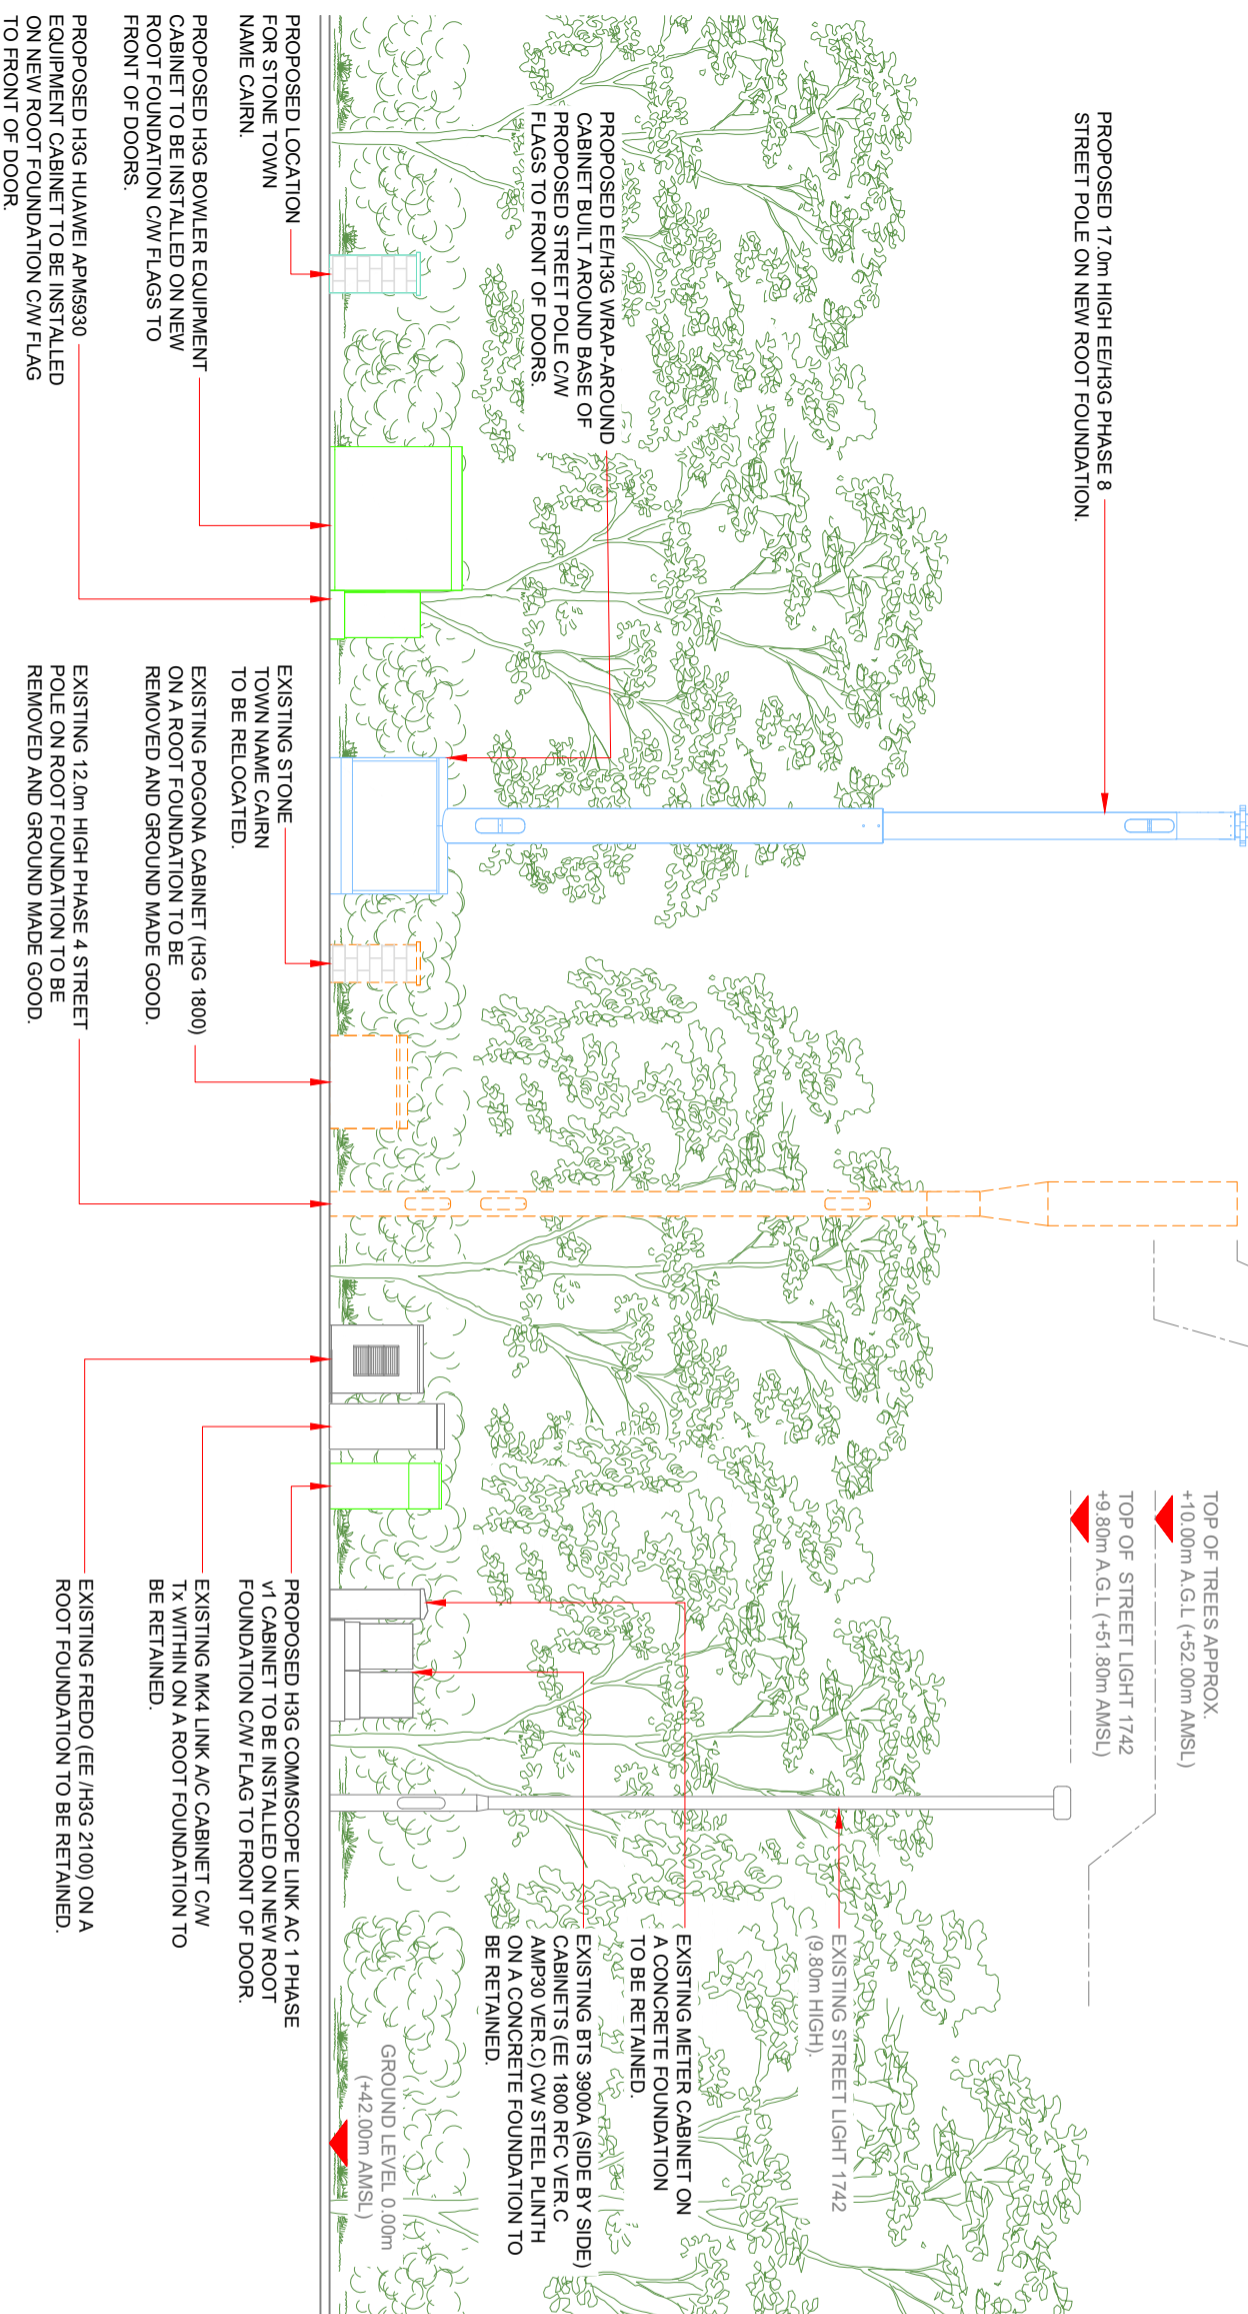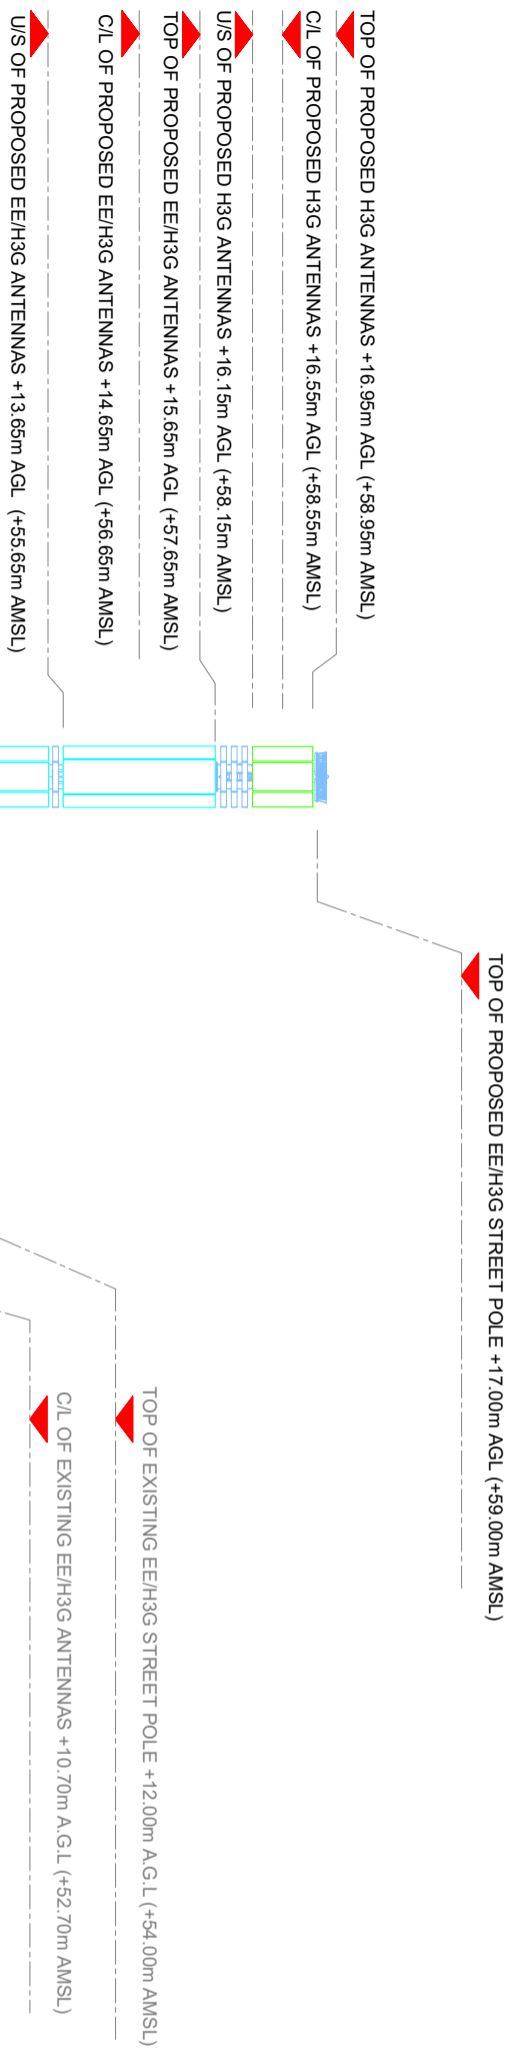

PROPOSED SITE ELEVATION

 

<p>Number: MBNL/EE/174203</p> <p>Date: 03/07/2020</p> <p>Drawn: A. Taylor</p> <p>Checked: A. Dobson</p> <p>Approved: A. Dobson</p> <p>Project: H3G UNILATERAL SW</p> <p>Revision / Upgrade Description: Tx & Antenna CA's Correlated on Dependencies, Cabinets updated. Existing Cabinets Removed from 266, G1900/U2100 Feeders revised to 550.</p>		<p>Number: MBNL</p> <p>Date: 12/08/2020</p> <p>Drawn: A. Taylor</p> <p>Checked: A. Dobson</p> <p>Approved: A. Dobson</p> <p>Project: H3G UNILATERAL SW</p> <p>Revision / Upgrade Description: Mk4 Cabinet revised to remain & Cairn relocated.</p>		<p>Number: MBNL</p> <p>Date: 22/05/2020</p> <p>Drawn: A. Taylor</p> <p>Checked: A. Dobson</p> <p>Approved: A. Dobson</p> <p>Project: H3G UNILATERAL SW</p> <p>Revision / Upgrade Description: First Issue - Site nomination dated. TBC</p>	
<p>Operator: MBNL</p> <p>Project: H3G UNILATERAL SW</p> <p>Purpose of Issue: Planning</p> <p>Issue: C</p>		<p>Operator: MBNL</p> <p>Project: H3G UNILATERAL SW</p> <p>Purpose of Issue: Planning</p> <p>Issue: B</p>		<p>Operator: MBNL</p> <p>Project: H3G UNILATERAL SW</p> <p>Purpose of Issue: Planning</p> <p>Issue: A</p>	



Hutchison 3G UK Limited
Shearwater, 20 Queen Road
Maidenhead, SL6 1EH
Tel: 01753 82000
Fax: 01753 82001
H3G Base Station Information line
0844 8240000
Address: Shearwater, Maidenhead, SL6 1EH

MBNL
Mobile Broadband Network Limited
Sixth Floor, Thames Tower, Station Road, Reading RG1 1LX

CLARKE
telecom
Unit E, Madison Place, Northampton Road,
Manchester, M40 5AG
Tel: 0161 785 4500 Fax: 0161 785 4501
Web: www.clarke-telecom.com

<p>Site Name: NEAR LAMP 1724 (P95881)</p>	
<p>Site ID: 769681</p>	
<p>Address: NEAR LAMP 1724 NORTH VERGE SHIELDS ROAD (A11018) CLEADON, SUNDERLAND SR6 7PX</p>	
<p>Title: 265 PROPOSED SITE ELEVATION</p>	
<p>Project: H3G UNILATERAL SW</p>	
<p>Purpose of Issue: PLANNING</p>	
<p>EE Call ID: 74020</p>	<p>MBNL Call ID: STY008</p>
<p>3UK Call ID: SR0080</p>	<p>Issue: C</p>
<p>Master Drawing No: 769681_STY008_74020_SR0080_M003</p>	