



Ordnance Survey
Ukmapcentre.com

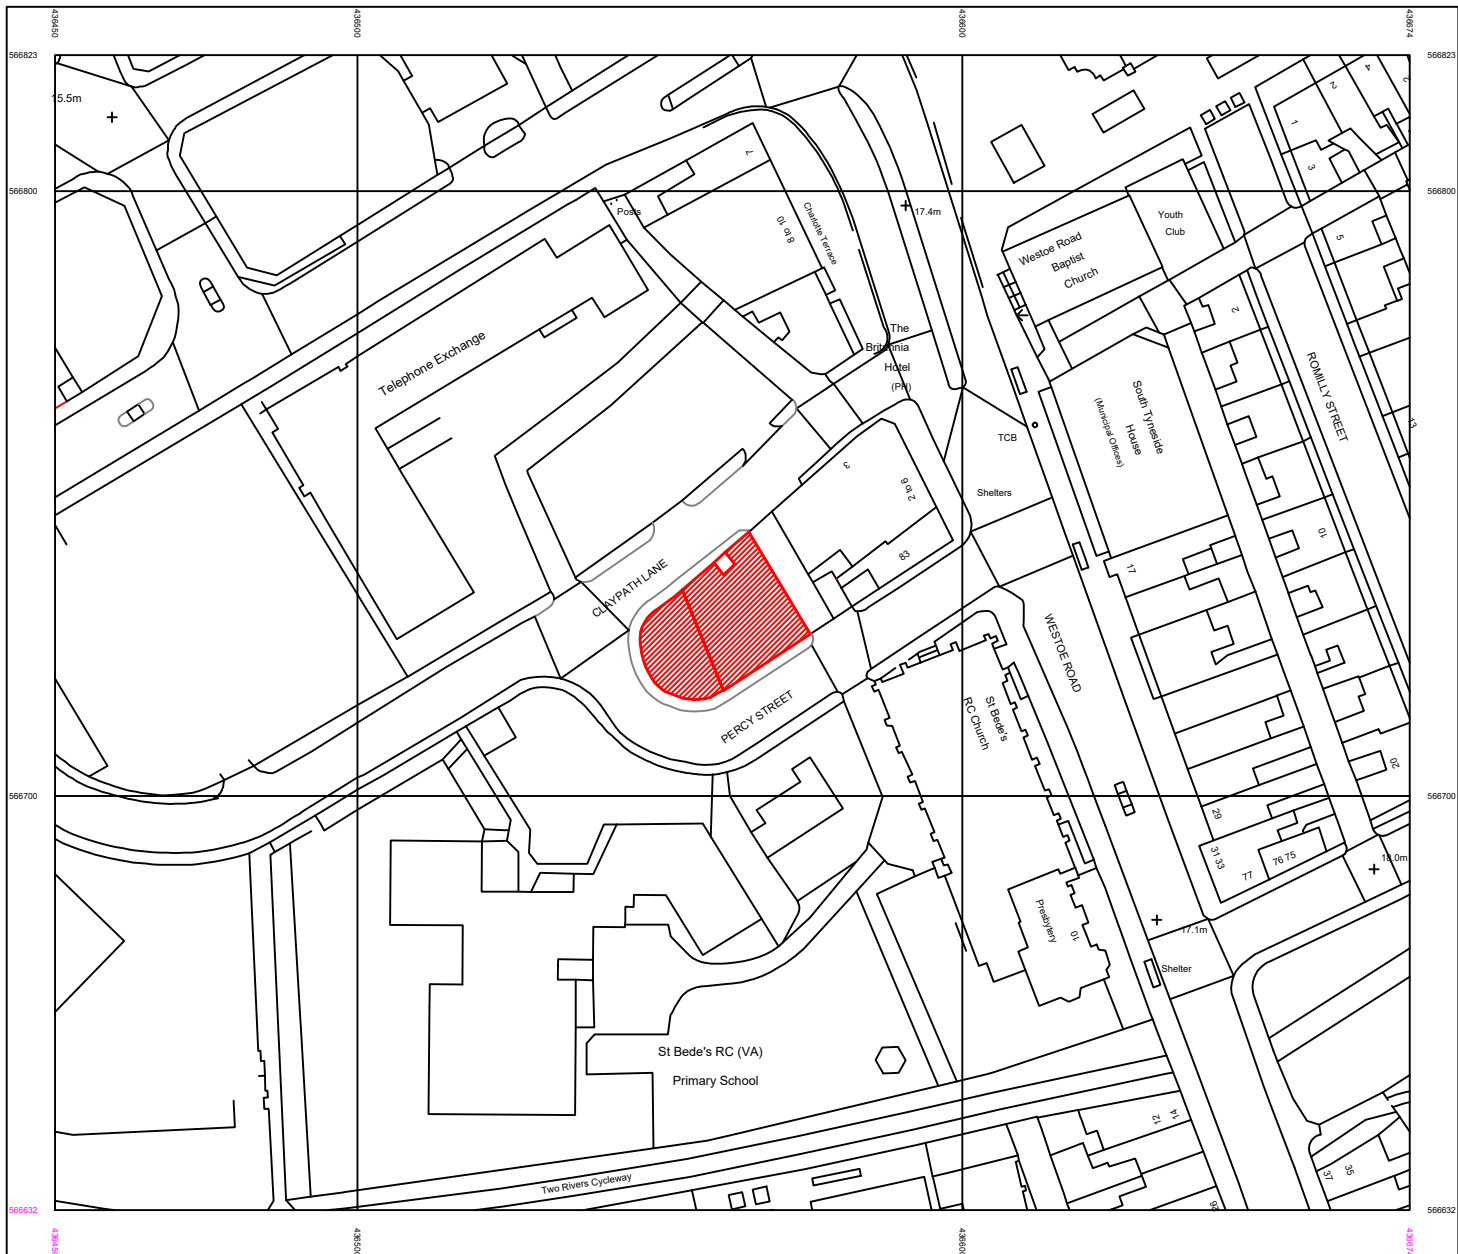


Scale 1:1000
© Crown copyright and database right 2018
Ordnance Survey licence 100048957
Reproduction in whole or in part is prohibited
without the prior permission of Ordnance Survey

Ordnance Survey
Ukmapcentre.com

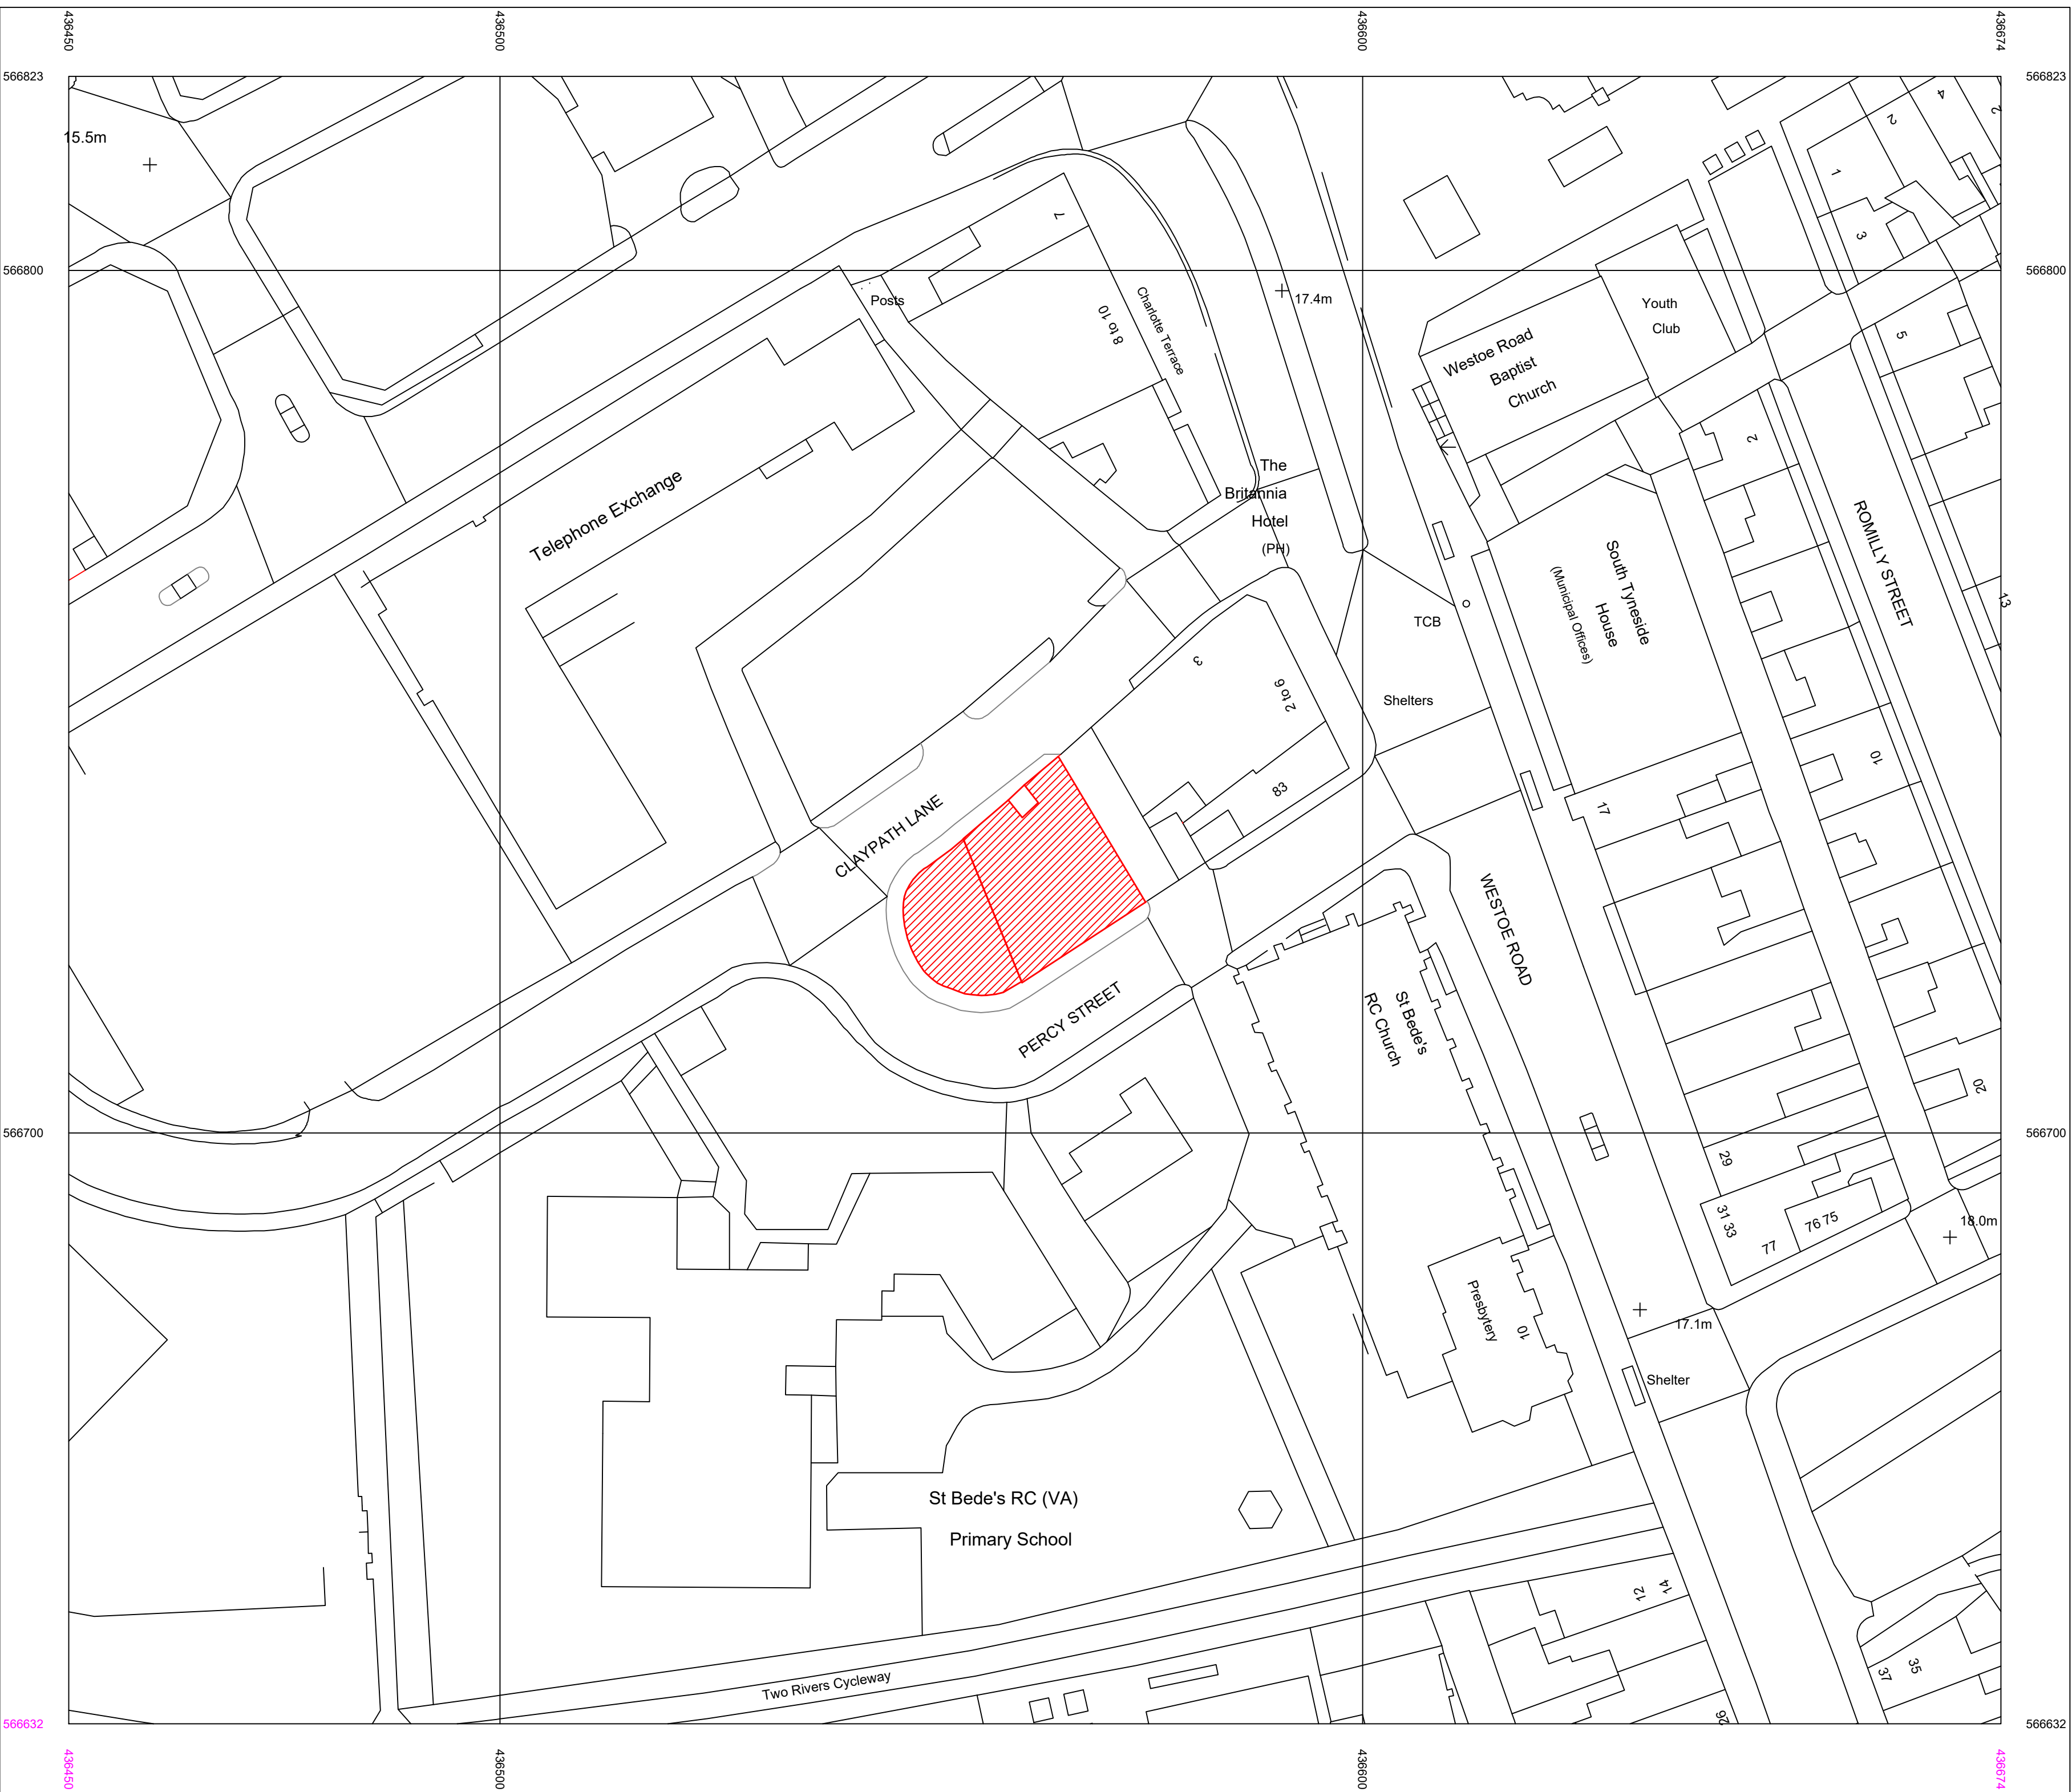

Serial number: 142639

© Crown copyright and database right 2018
Ordnance Survey licence 100048957
Reproduction in whole or in part is prohibited
without the prior permission of Ordnance Survey

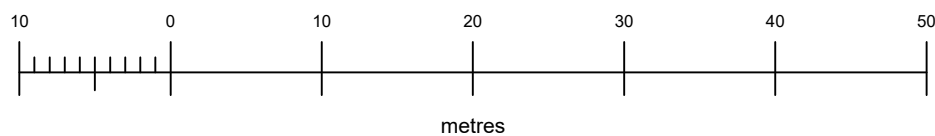

All dimensions must be checked on site and not scaled from this drawing
Any discrepancies to be reported to the supervising officer

GENERAL:
1. All works carried out to be in strict accordance with the Building Regs. 2000 inc. latest amendments to fully satisfy Building Control.
2. All contractors to fully comply with Building Regs. C of P, BS etc. to a state that all necessary Building Control and Environmental Health certificates can be obtained on completion of works.
3. All contractors are responsible for site visits, conditions and details. Site dimensions are the full responsibility of the contractor.
4. Drawings are not to contribute to 'Schedule of Conditions' or Structural Survey.

BUILDING:
1. Minimum bearing for Structural Steelwork to be 150mm.
2. All Structural Steelwork to be manufactured to BS5500 and to be fire protected to 1 hour in accordance with schedule 8/10.
3. All reinforced conc. to be in accordance with BS 8110.
4. All timber to comply with BS 5268 pt. 2. Structural timbers to be impregnated with preservative.
5. All ceilings/floors to comply with current Fire Resistance/Protection requirements all ready for finishes.
6. All glazing doors, windows to comply with Part N Building Regs. toughened glass to BS as required.
7. Remove/demolish walls where dotted to Structural Engineers requirements. Allow for propping and screening to enable safe working. Insert all steel intels, beams etc. to Structural Engineers details.
8. Structural Engineer to provide details/calculations of all structural works for approval by Building Control.
9. Details & calculations to be provided by manufacturer of staircases for approval by Building Control.

FIRE:
1. All means of escape to be to the full satisfaction of the local authority and Fire Officer.
Also to comply with Reg. B1. All doors to exit routes to be panic fastenings only.
2. Emergency lighting to comply with BS 5266 pt. 1, current edition. Detail drawings by electrical contractor.
3. Fire alarm system installation to comply with BS 5839 pt. 4, current edition. Audible alarms throughout.
4. All upholstered furniture to comply with BS 5862 1990. Ignition source 0 (cigarette test), ignition source 1, and ignition source 5 (timber crib test).
5. All curtains, drapes, tented ceilings etc. to be flame proofed to BS 3119 1959 (test method) with BS 3120 1959 and in conjunction with BS 4538 1976 test and BS 5867 pt. 2 1980 Type B test D.O.E. P.S.A. specification 7 using source 5.
6. All doors (unless otherwise stated on drawing) to be 1/2 hour fire resistant (FD30S) with overhead door closer as spec. Door frames to have 25mm fire check rebates to BS 476, all complete with smoke seals and intumescent strips.
7. All fire exit signs as necessary to health & safety regulations to have green background and white 'Running Man' logo. To comply with BS.
8. Fire doors to be marked 'FIRE DOOR KEEP SHUT' in specified hardware.
9. Surface finish to public areas - Class One. To escape routes - Class 0.
10. Artificial foliage/decor items to be incombustible. Suppliers must submit certification on supply.
11. Fire appliances to be supplied to BS5306 Part 3.

PLUMBING AND DRAINAGE:
1. All plumbing and drainage to strictly conform with building regs. and standards inc. all sanitary facilities to BS 6445. All basins and urinals to have 75mm deep seal and siphon traps and 50mm dia. wastes.
2. Existing & new plumbing/drainage to be fully tested and left in good working order on completion.

ELECTRICAL WORK:
1. All new and existing installations (inc. any special effects sound/light equipment) to fully comply with latest IEE Regulations and any relevant PEL of local authority requirements.
Electrical and sound/light contractors are responsible for testing and checking to ensure all works are up to required standards.
All sound/light installation and programming to be to the satisfaction of the designer.

VENTILATION:
1. All ventilation to comply with Building Regs. AD F1 to all areas, inc. any existing areas.
2. Public areas adapted/replaced to give 15 a/c per hour.
3. Internal toilet cobbles to be mechanically vented. Allow 3 air changes/hour with 15 min. overrun.
4. Kitchen ventilation to be capable of 40 a/c per hour.
Mechanical ventilation to be provided to new office / staff areas with adequate intake air.

CCTV:
1. CCTV to be installed to meet any requirements of the police and/or liquor licensing magistrates.

B	-	-
A	-	-

**studio one
DESIGN**
17 Beechwood Street
Thornhill
Sunderland
SR2 7LU
gamc73@gmail.com
07784 850162

client
MR TONY SINGH_PREMIER LEISURE LTD

job title
THE MALTINGS_
9 CLAYPATH LANE
SOUTH SHIELDS
NE33 4PG

drawing title
SITE LOCATION PLANS
1_1250 - 1_500

scale 1_1250 / 1_500 @ A1

date JULY 2018 drawn by

drg. no.
05