


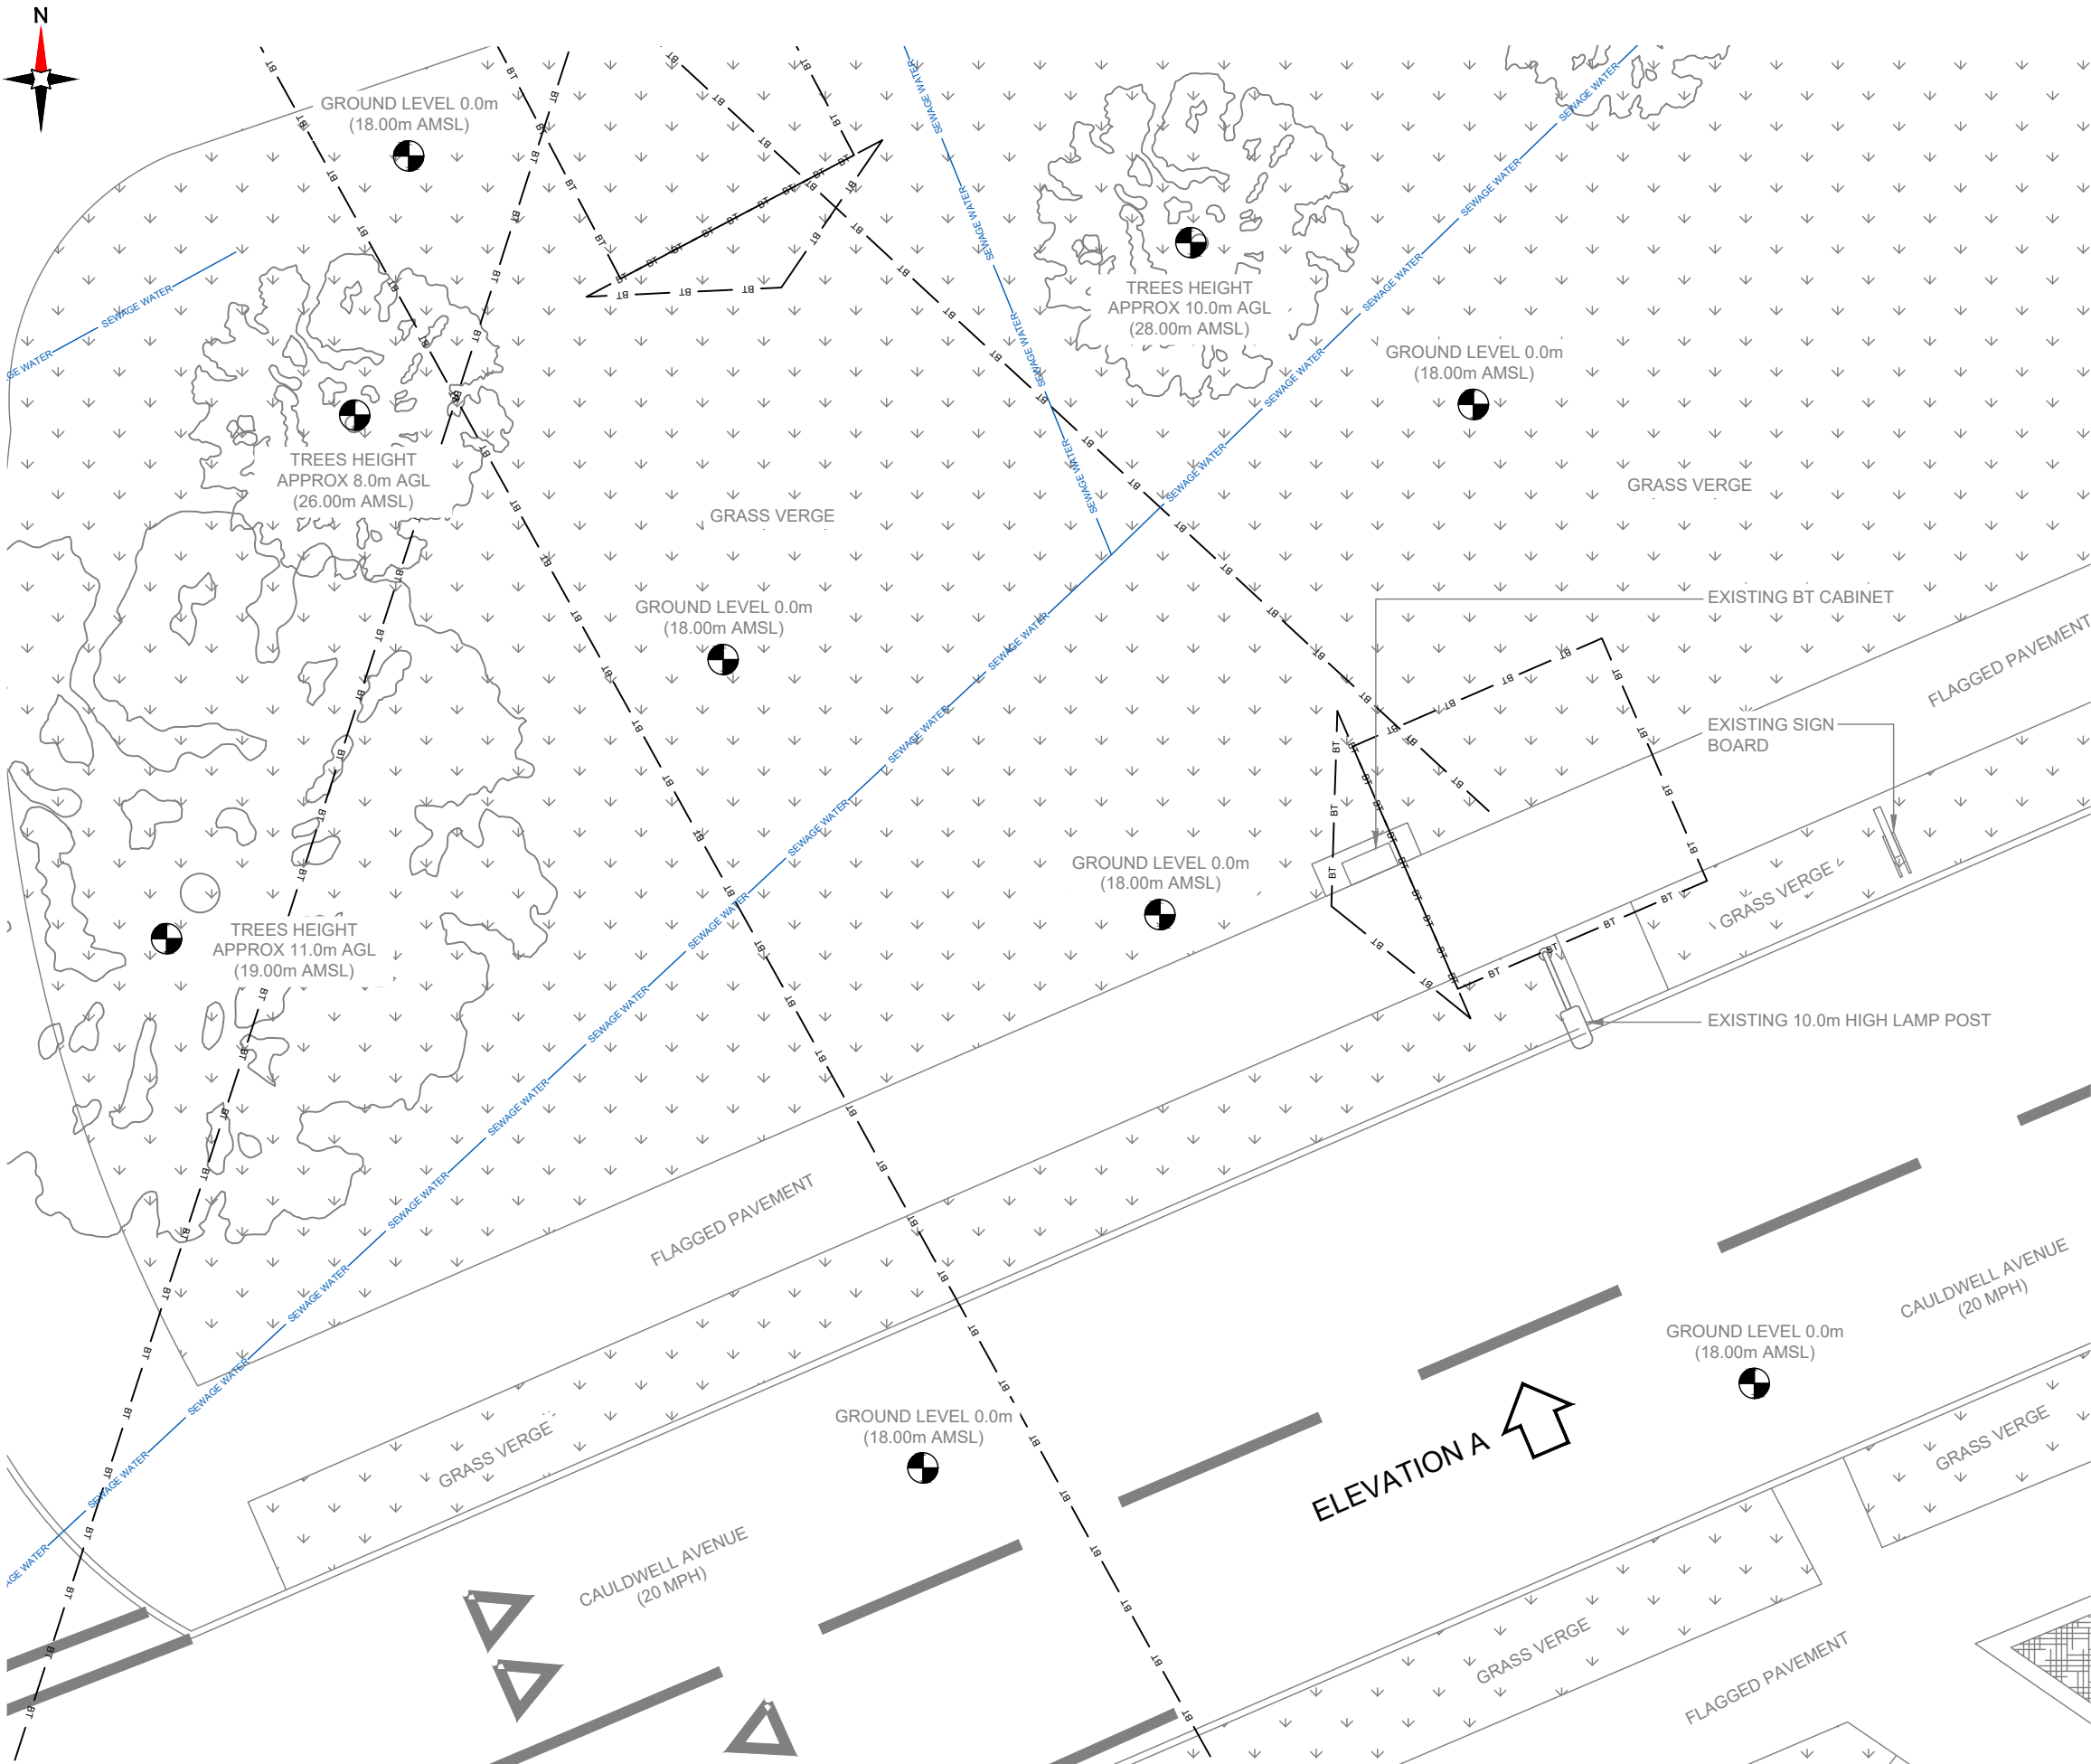

NOTES:
1. ALL DIMENSIONS IN MM UNLESS OTHERWISE NOTED.

SERVICES:

— HV ELECTRIC — HV ELECTRIC — HV ELECTRIC —

— LV ELECTRIC — LV ELECTRIC — LV ELECTRIC —

— ELECTRIC — ELECTRIC — ELECTRIC —

— GAS LP MAINS — GAS LP MAINS —

— MAINS WATER — MAINS WATER —

— SEWAGE WATER — SEWAGE WATER —

— TELECOMS — TELECOMS —

— GPR — GPR —

Master:	MBNL / EE / H3G:	Project:	Purpose of Issue:	Issue:
M001	H3G	DENSIFICATION SW	Planning	A
Date:	03/03/2023	Revision / Upgrade Description:		
Drawn:	M.Bagya	First Issue		
Checked:	R.Brown			
Approved:	R.Brown			



Hutchison 3G UK Limited
Green Park, 450 Longwater Avenue
Reading, RG30 3UR
Tel: 01628 765 000
Fax: 01628 765 001

H3G Base Station Information line:
0845 6043000
Available 8am-8pm Monday to Friday

Design Consultant & Principal Contractor:

CLARKE telecom

Unit E, Madison Place, Northampton Road,
Manchester, M40 5AG
Tel: 0161 785 4500 Fax: 0161 785 4501
Web: www.clarke-telecom.com

Site Name:	GRASS VERGE ON CAULDWELL AVENUE		
Site ID:	STY22972		
Address:	CAULDWELL AVENUE CAULDWELL SOUTH SHIELDS SOUTH TYNESIDE NE34 0SD		
Title:	100 EXISTING SITE PLAN		
Project:	H3G DENSIFICATION STREETWORKS		
Purpose of Issue:	PLANNING		
	MBNL Cell ID:	3UK Cell ID:	
	N/A	N/A	
Master Drawing No:	STY22972_NA_NA_M001_H3G_DNSW_GA_A		Issue:
			A