


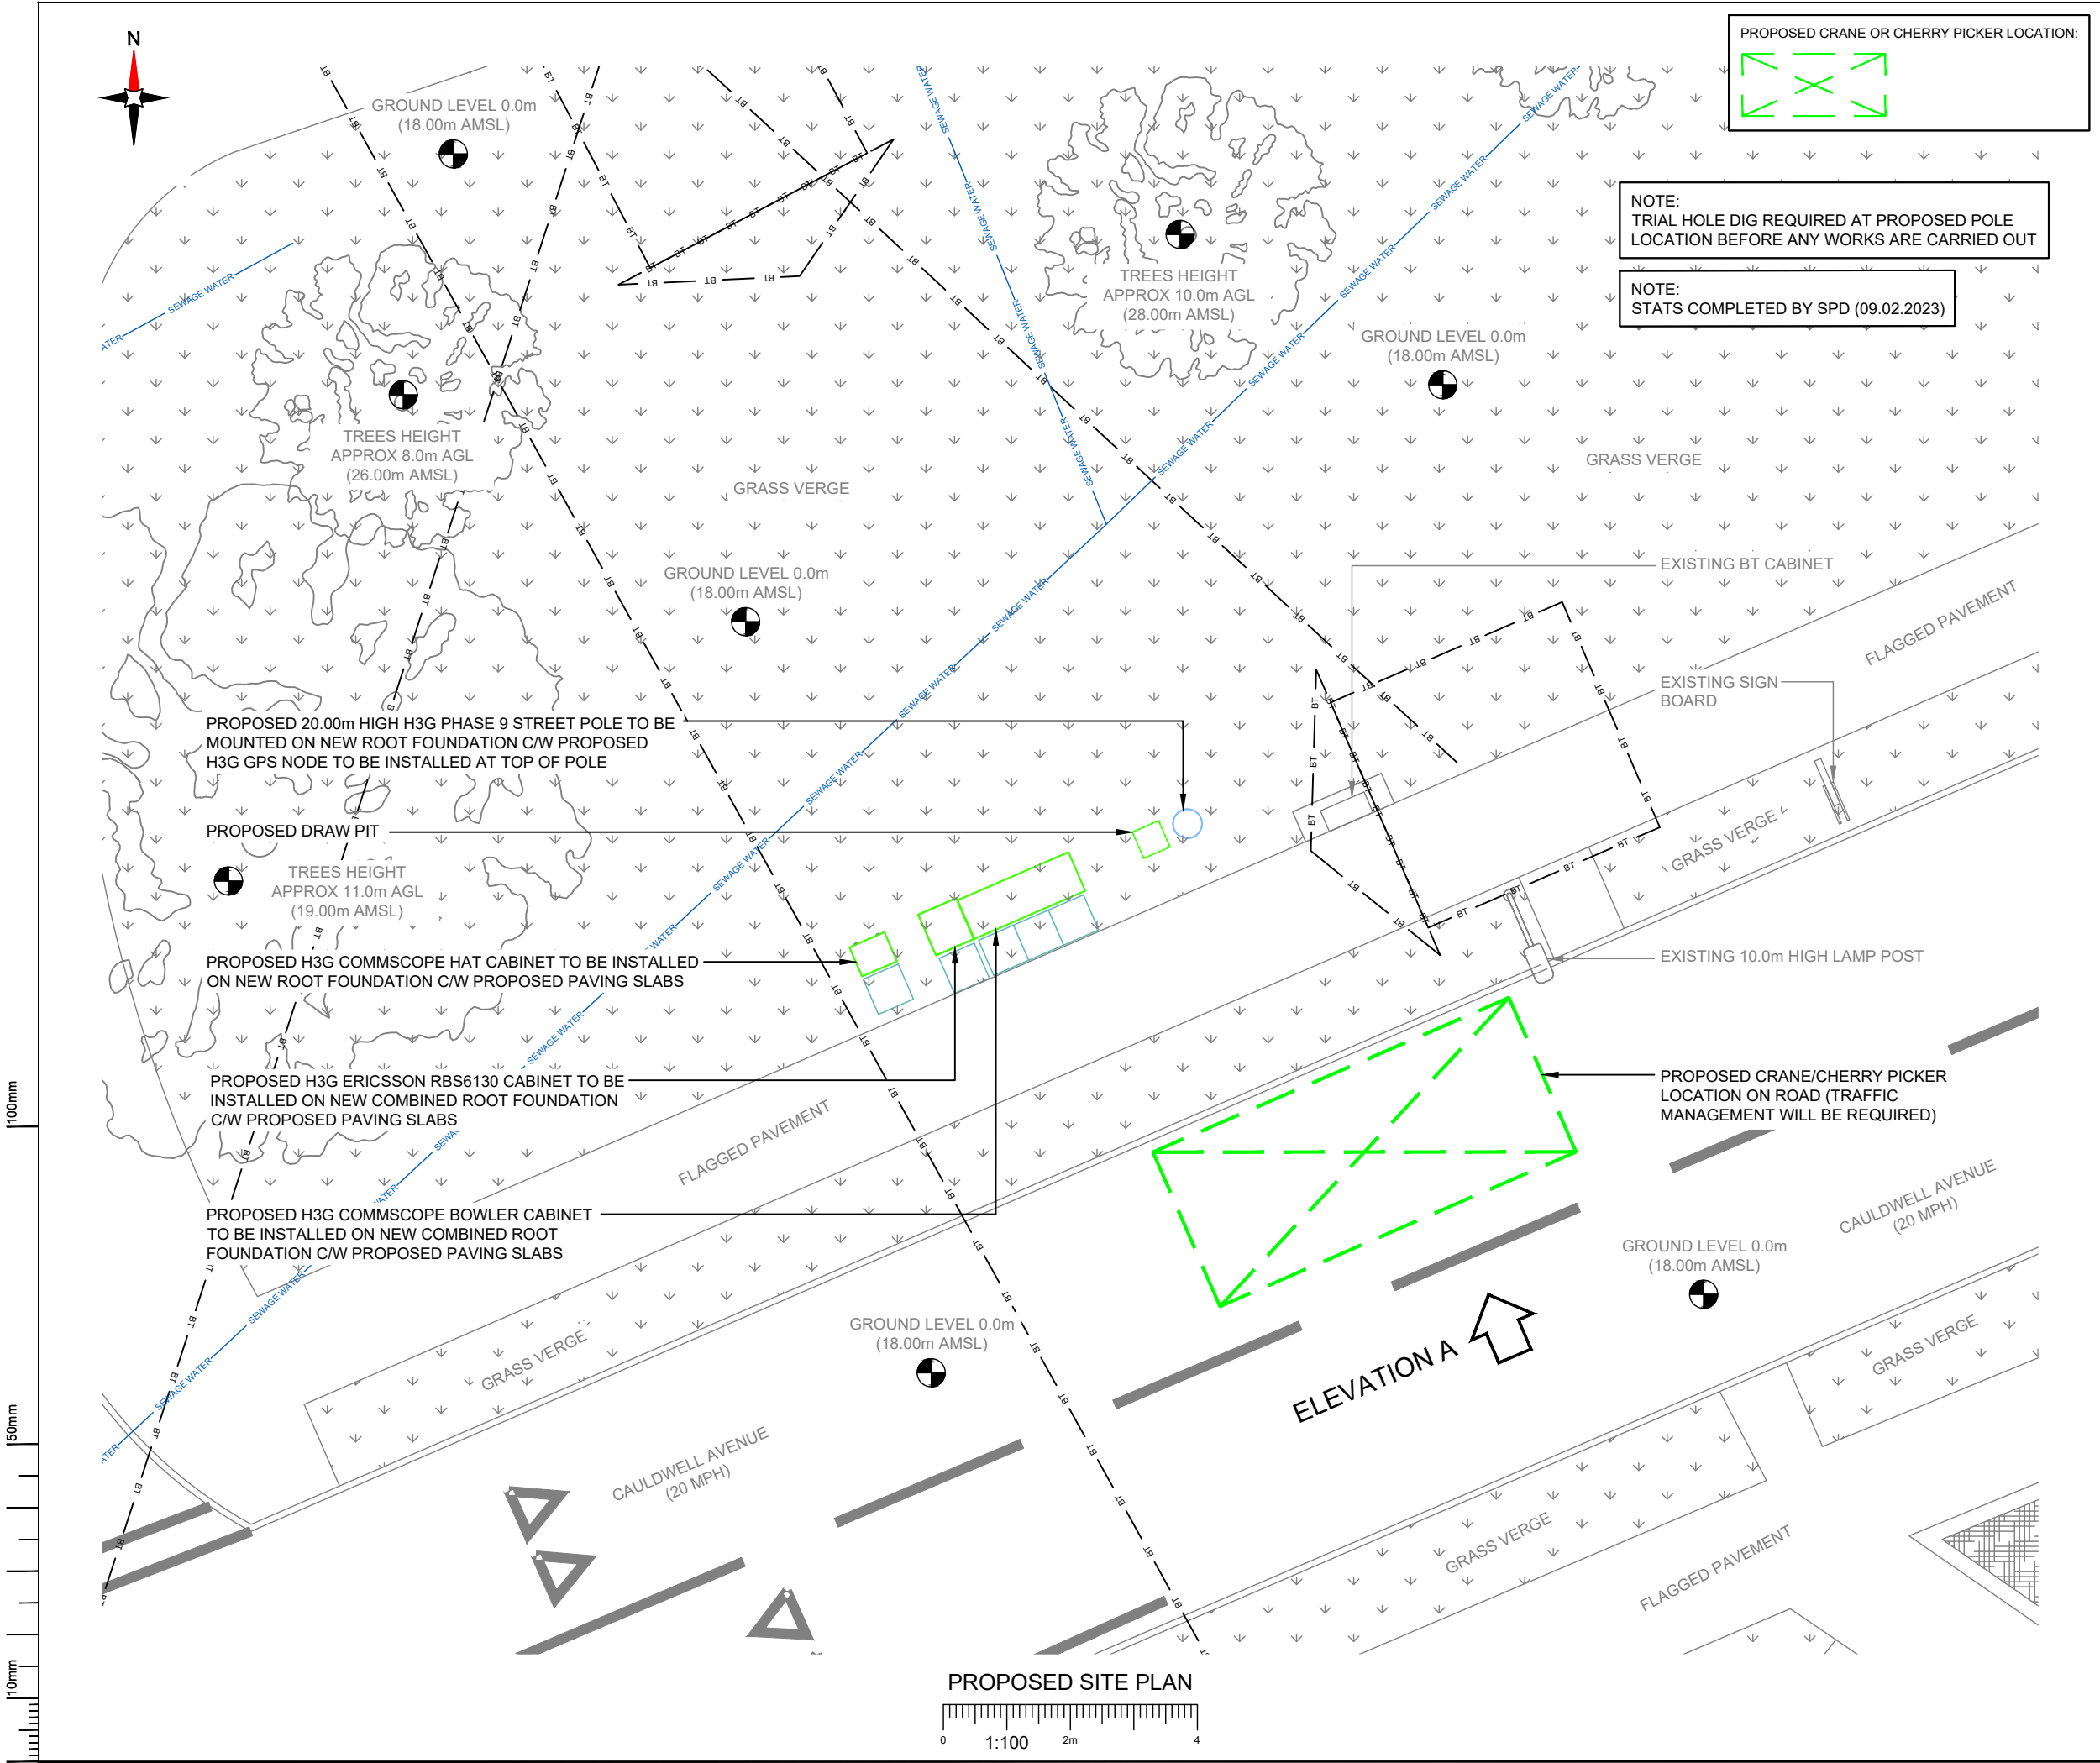

NOTES:

1. ALL DIMENSIONS IN MM UNLESS OTHERWISE NOTED.

SERVICES:		HV ELECTRIC	HV ELECTRIC	HV ELECTRIC
		LV ELECTRIC	LV ELECTRIC	LV ELECTRIC
		ELECTRIC	ELECTRIC	ELECTRIC
		GAS LP MAINS	GAS LP MAINS	GAS LP MAINS
		MAINS WATER	MAINS WATER	MAINS WATER
		SEWAGE WATER	SEWAGE WATER	SEWAGE WATER
		TELECOMS	TELECOMS	TELECOMS
		GPR	GPR	GPR

Master:	MBNL / EE / H3G:	Project:	Purpose of Issue:	Issue:
M001	H3G	DENSIFICATION SW	Planning	A
Date:	03/03/2023	Revision / Upgrade Description:		
Drawn:	M.Bagya	First Issue		
Checked:	R.Brown			
Approved:	R.Brown			



Hutchison 3G UK Limited
Green Park, 450 Longwater Avenue
Reading, RG30 3UR
Tel: 01628 765 000
Fax: 01628 765 001

H3G Base Station Information line:
0845 6043000
Available 8am-8pm Monday to Friday

Design Consultant & Principal Contractor:



Unit E, Madison Place, Northampton Road,
Manchester, M40 5AG
Tel: 0161 785 4500 Fax: 0161 785 4501
Web: www.clarke-telecom.com

Site Name:

GRASS VERGE ON CAULDWELL AVENUE

Site ID:

STY22972

Address:

CAULDWELL AVENUE
CAULDWELL
SOUTH SHIELDS
SOUTH TYNESIDE
NE34 0SD

Title:

210 PROPOSED SITE PLAN

Project:

H3G DENSIFICATION STREETWORKS

Purpose of Issue:

PLANNING

MBNL Cell ID:	3UK Cell ID:
N/A	N/A

Master Drawing No:

STY22972_NA_NA_M001_H3G_DNSW_GA_A

Issue:

A