


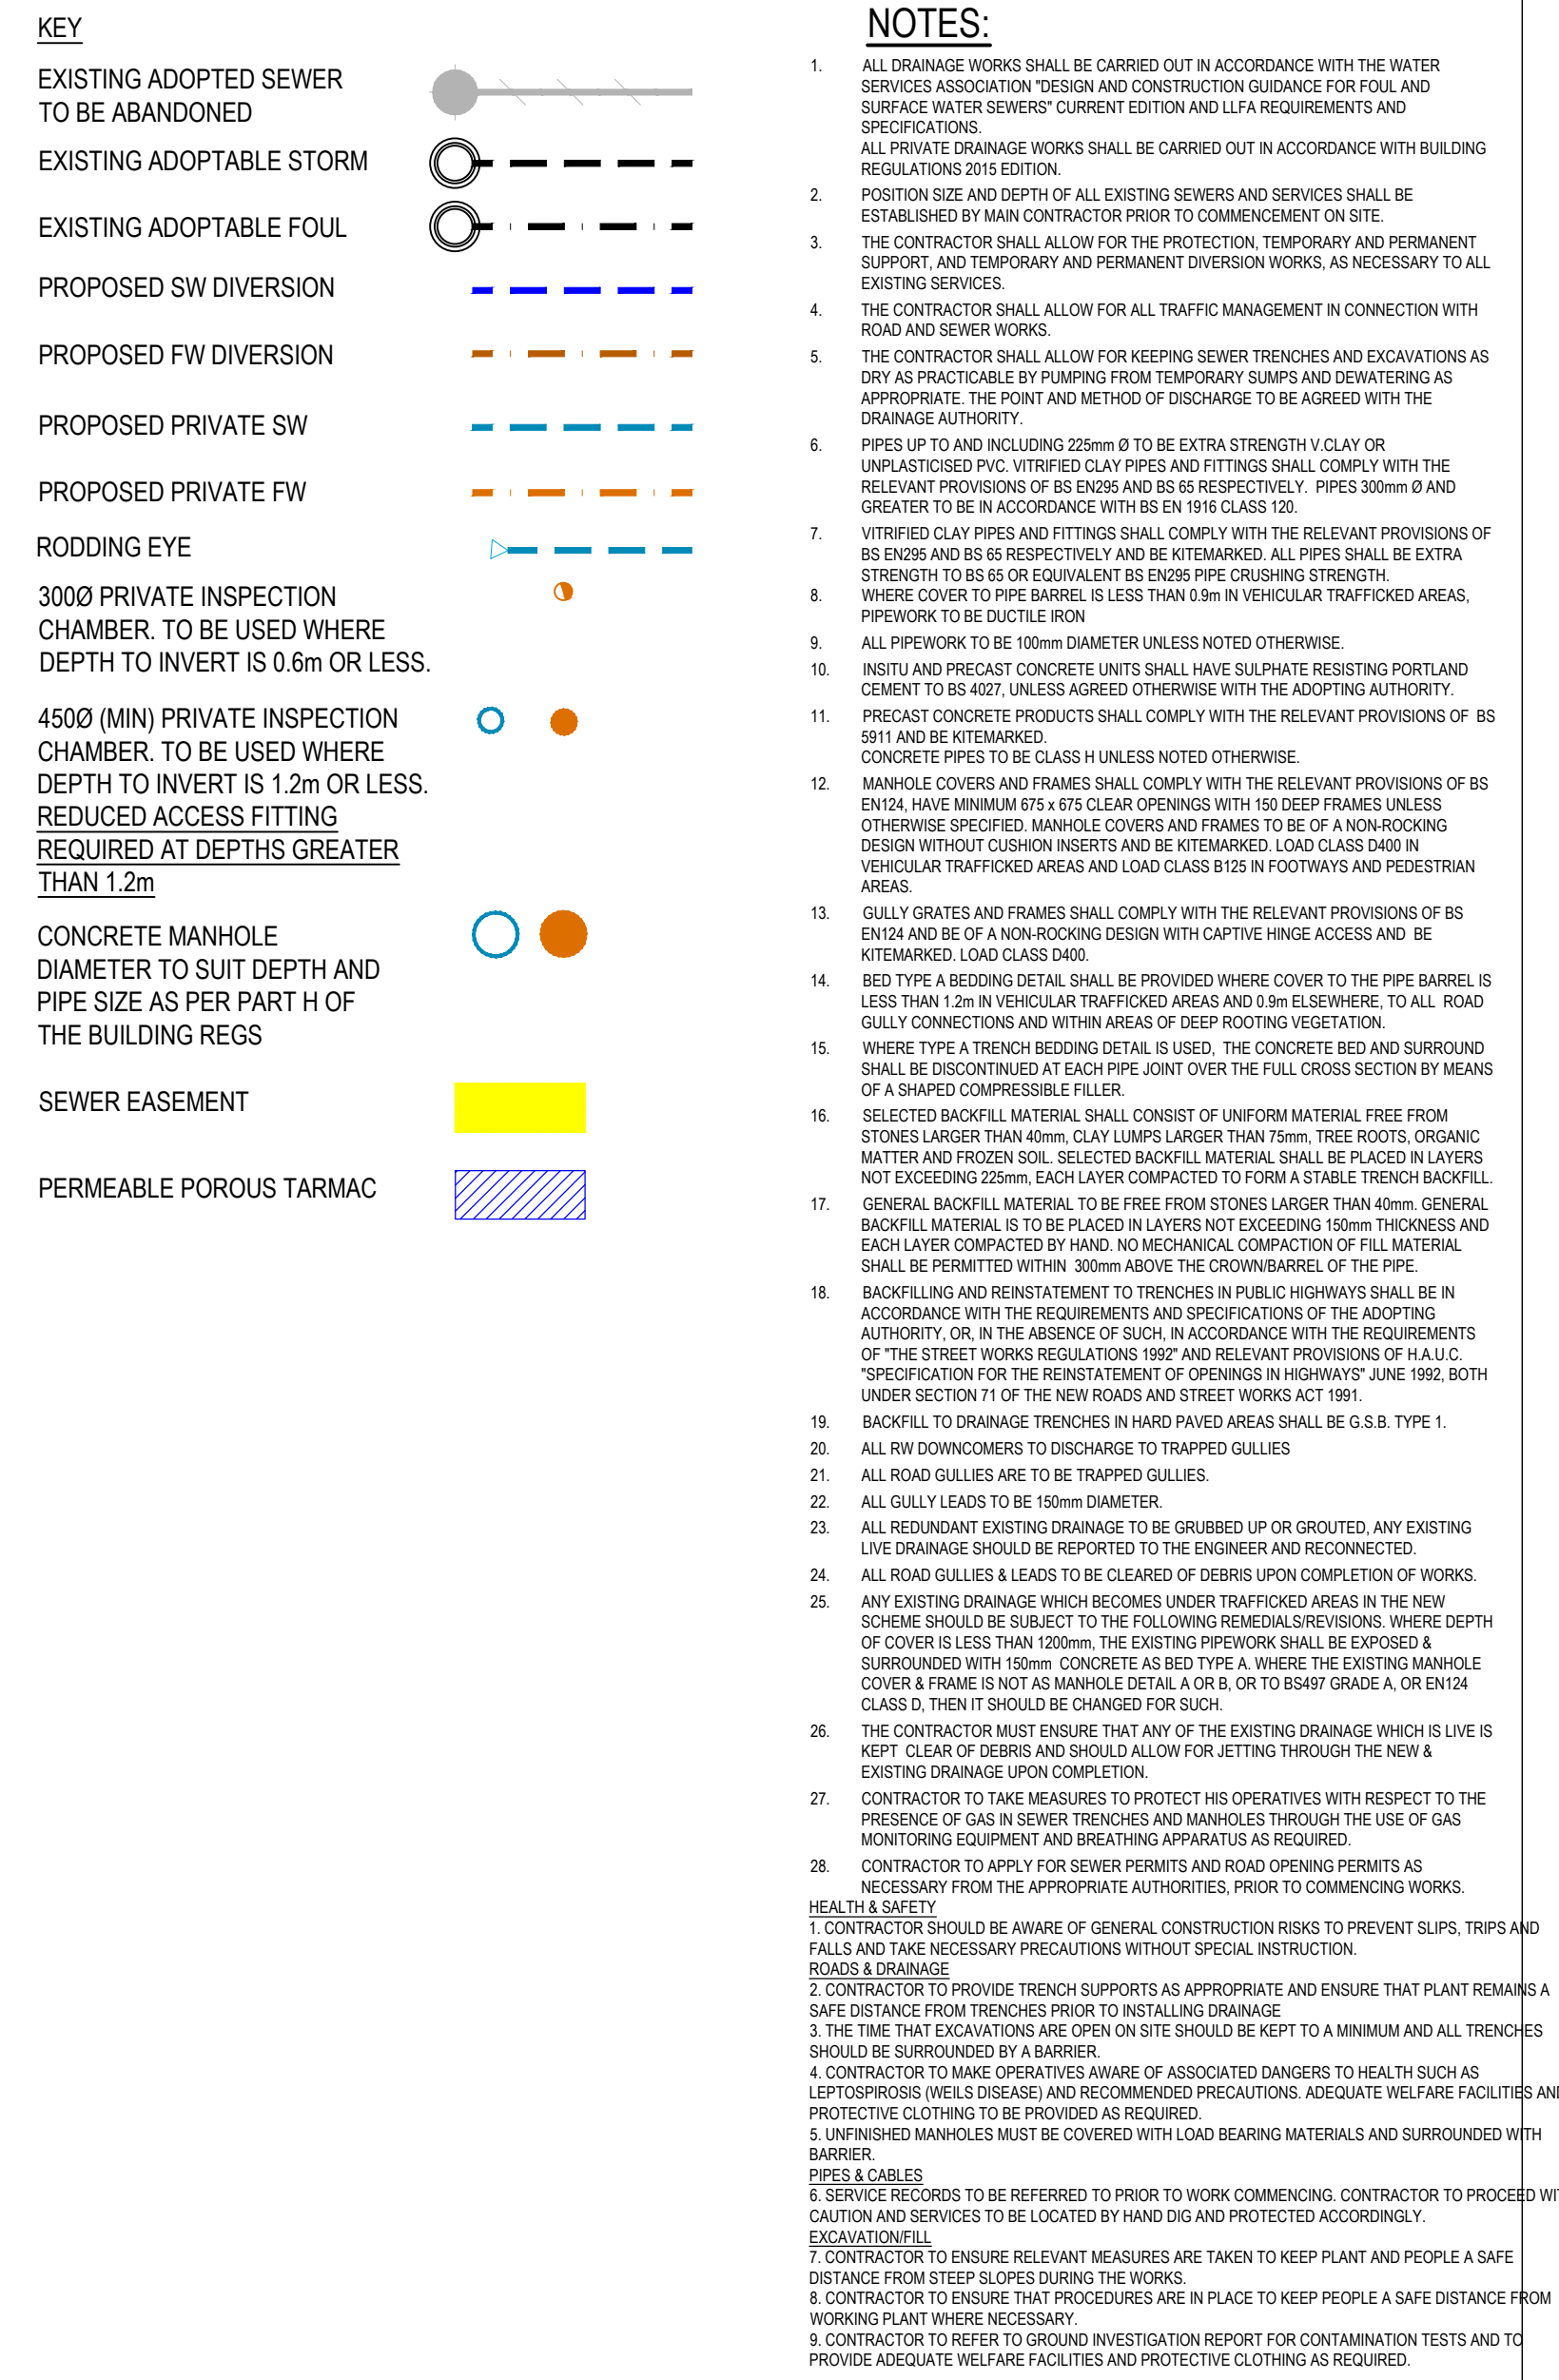

 Portland <i>consulting engineers</i>			
10 Benkards, The Watermark, Galsbrook, Tyne & Wear, NE11 6DY T: 0191 4610770 W: www.portlandconsulting.co.uk F: 0191 460308 E: info@portlandconsulting.co.uk			
Client Karbon Homes			
Project STC Extra Care Scheme Hebburn			
Drawing Title Proposed Drainage Layout			
Scale	1:250	Sheet Size	A0
Drawing By	KC	Checked by	SH
Approved by	LRB	Date	31/03/23
Construction			
Project No.	2022092	Drawing No.	O10-01
		Revision	AE
This drawing and design is to be used in connection with the above project. This drawing is the property of Portland Consulting Engineers, and must not be issued, copied or otherwise reproduced without their prior written consent. If it is to be used in other projects, it shall be done under licence only. Do not scale from this drawing. It is the responsibility of the client to ensure that all dimensions are correctly stated. Any apparent discrepancy shall be brought to the attention of Portland Consulting Engineers.			
 		ISO 9001 REGISTERED FIRM	