



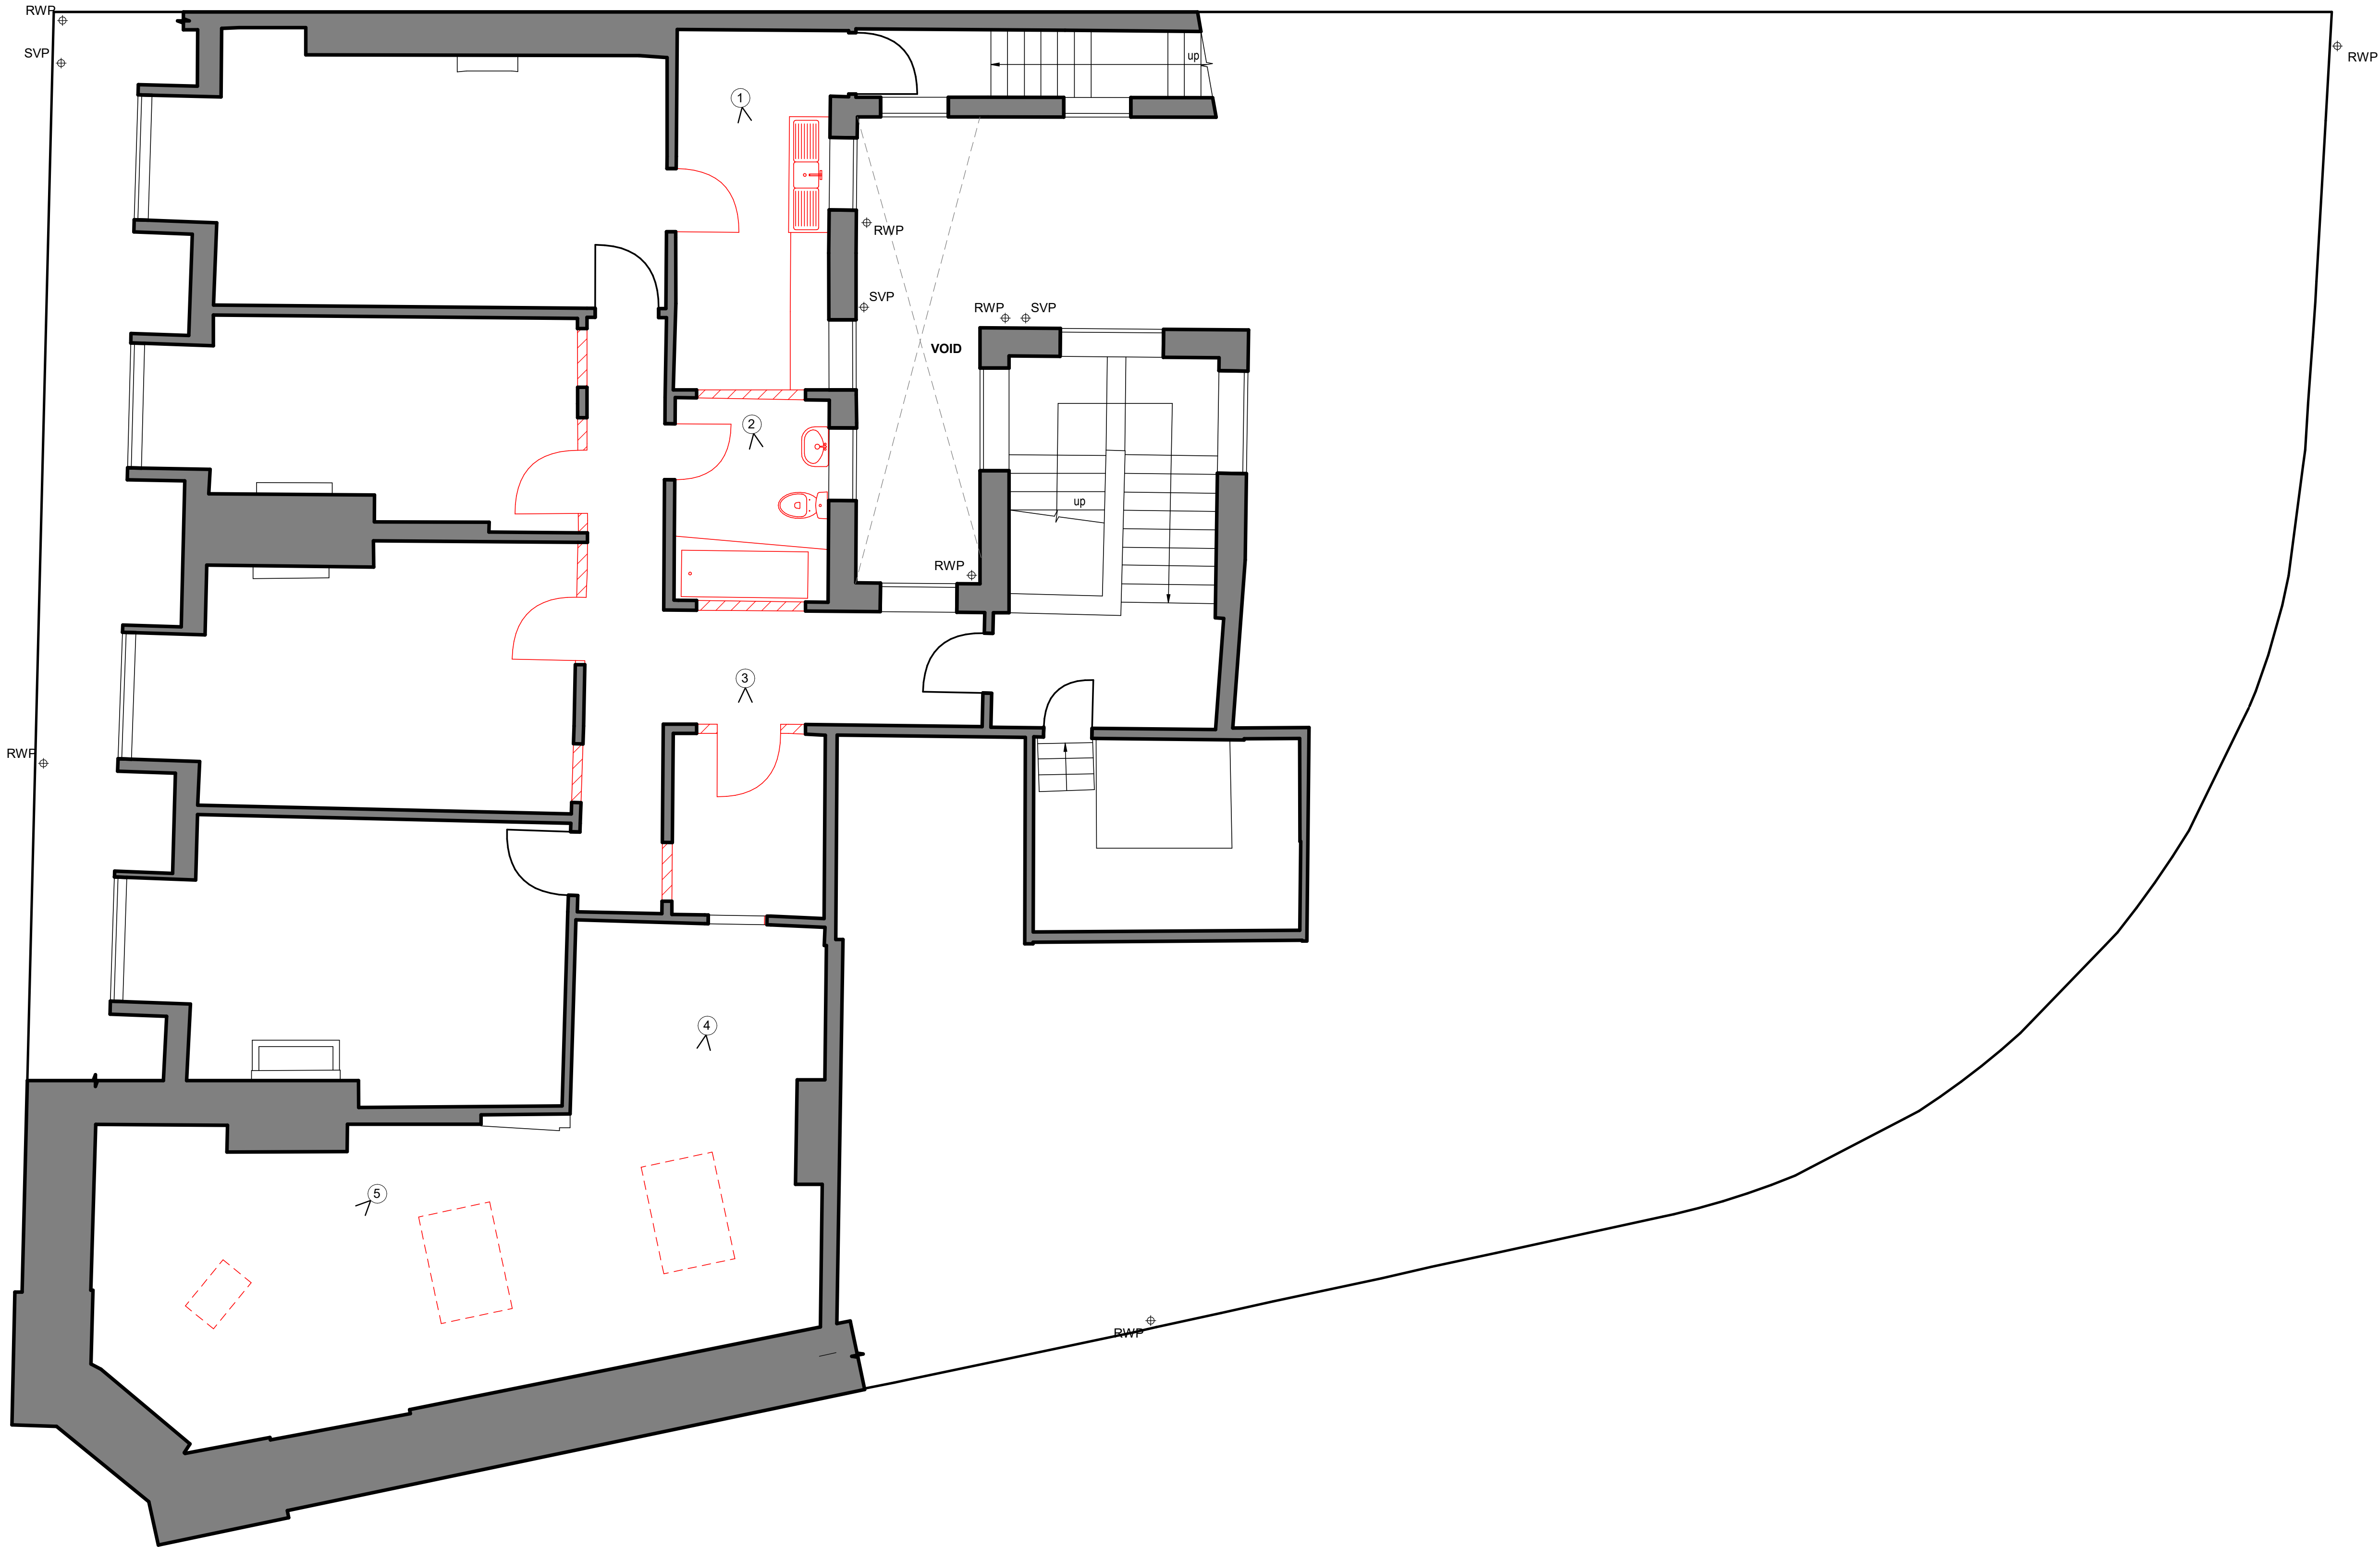


Key

- Existing Building Elements
- Demolished Building Elements
- Existing Elements Moved / Repurposed

DEMOLITION NOTES - FOURTH FLOOR

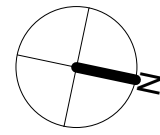

① New opening to be created for proposed corridor and kitchen fittings to be removed. All electrical, mechanical and plumbing fixtures to be isolated and removed. Disturbed surfaces to be made good.

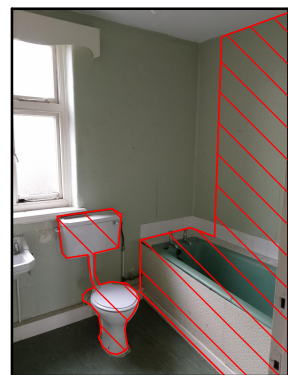


② New opening to be created for proposed corridor and bathroom fittings to be removed. All electrical, mechanical and plumbing fixtures to be isolated and removed. Disturbed surfaces to be made good.



③ Existing door removed and opening enlarged to both openings into roof space. Disturbed surfaces to be made good.



④ 2 no. openings to be made in roof for proposed Studio Apartment lounge / bedroom area.

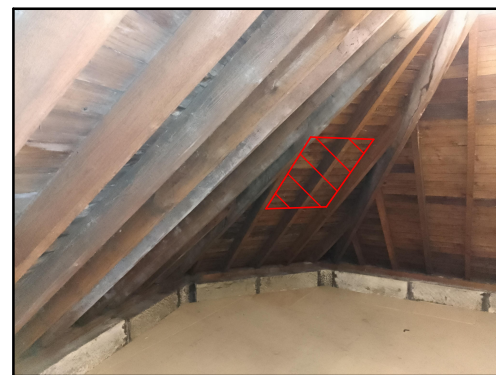

⑤ 1 no. opening to be made in roof for proposed Studio Apartment bathroom area.



P1	Planning Submission	21.07.25
Revision:	Description:	Date:
Project:	Originator:	Volume:
24.044	CA	XX
Project:	Level:	Type:
04	DR	A
Project:	Number:	Revision:
00.014	P1	
Project:	Former Barclays Bank 1 King Street South Shields NE33 1DA	CAL Project No: 24.044
Client:	Regal Bifrons Properties Ltd	
Drawing:	Fourth Floor Demolition Plan	
Scale:	1 : 50	Print Size: A1
Drawn By:	RH	Checked By: CK

Map House,
3 George Stephenson Court,
Preston Farm,
Stockton on Tees,
TS18 3TG

t : 01642 062521
e : info@createarchitecture.co.uk

Architectural Consultants | Land & Property Consultants |
a Private Limited Company - reg. no. 08859320

CIAT
affiliate group
body corporate