

 


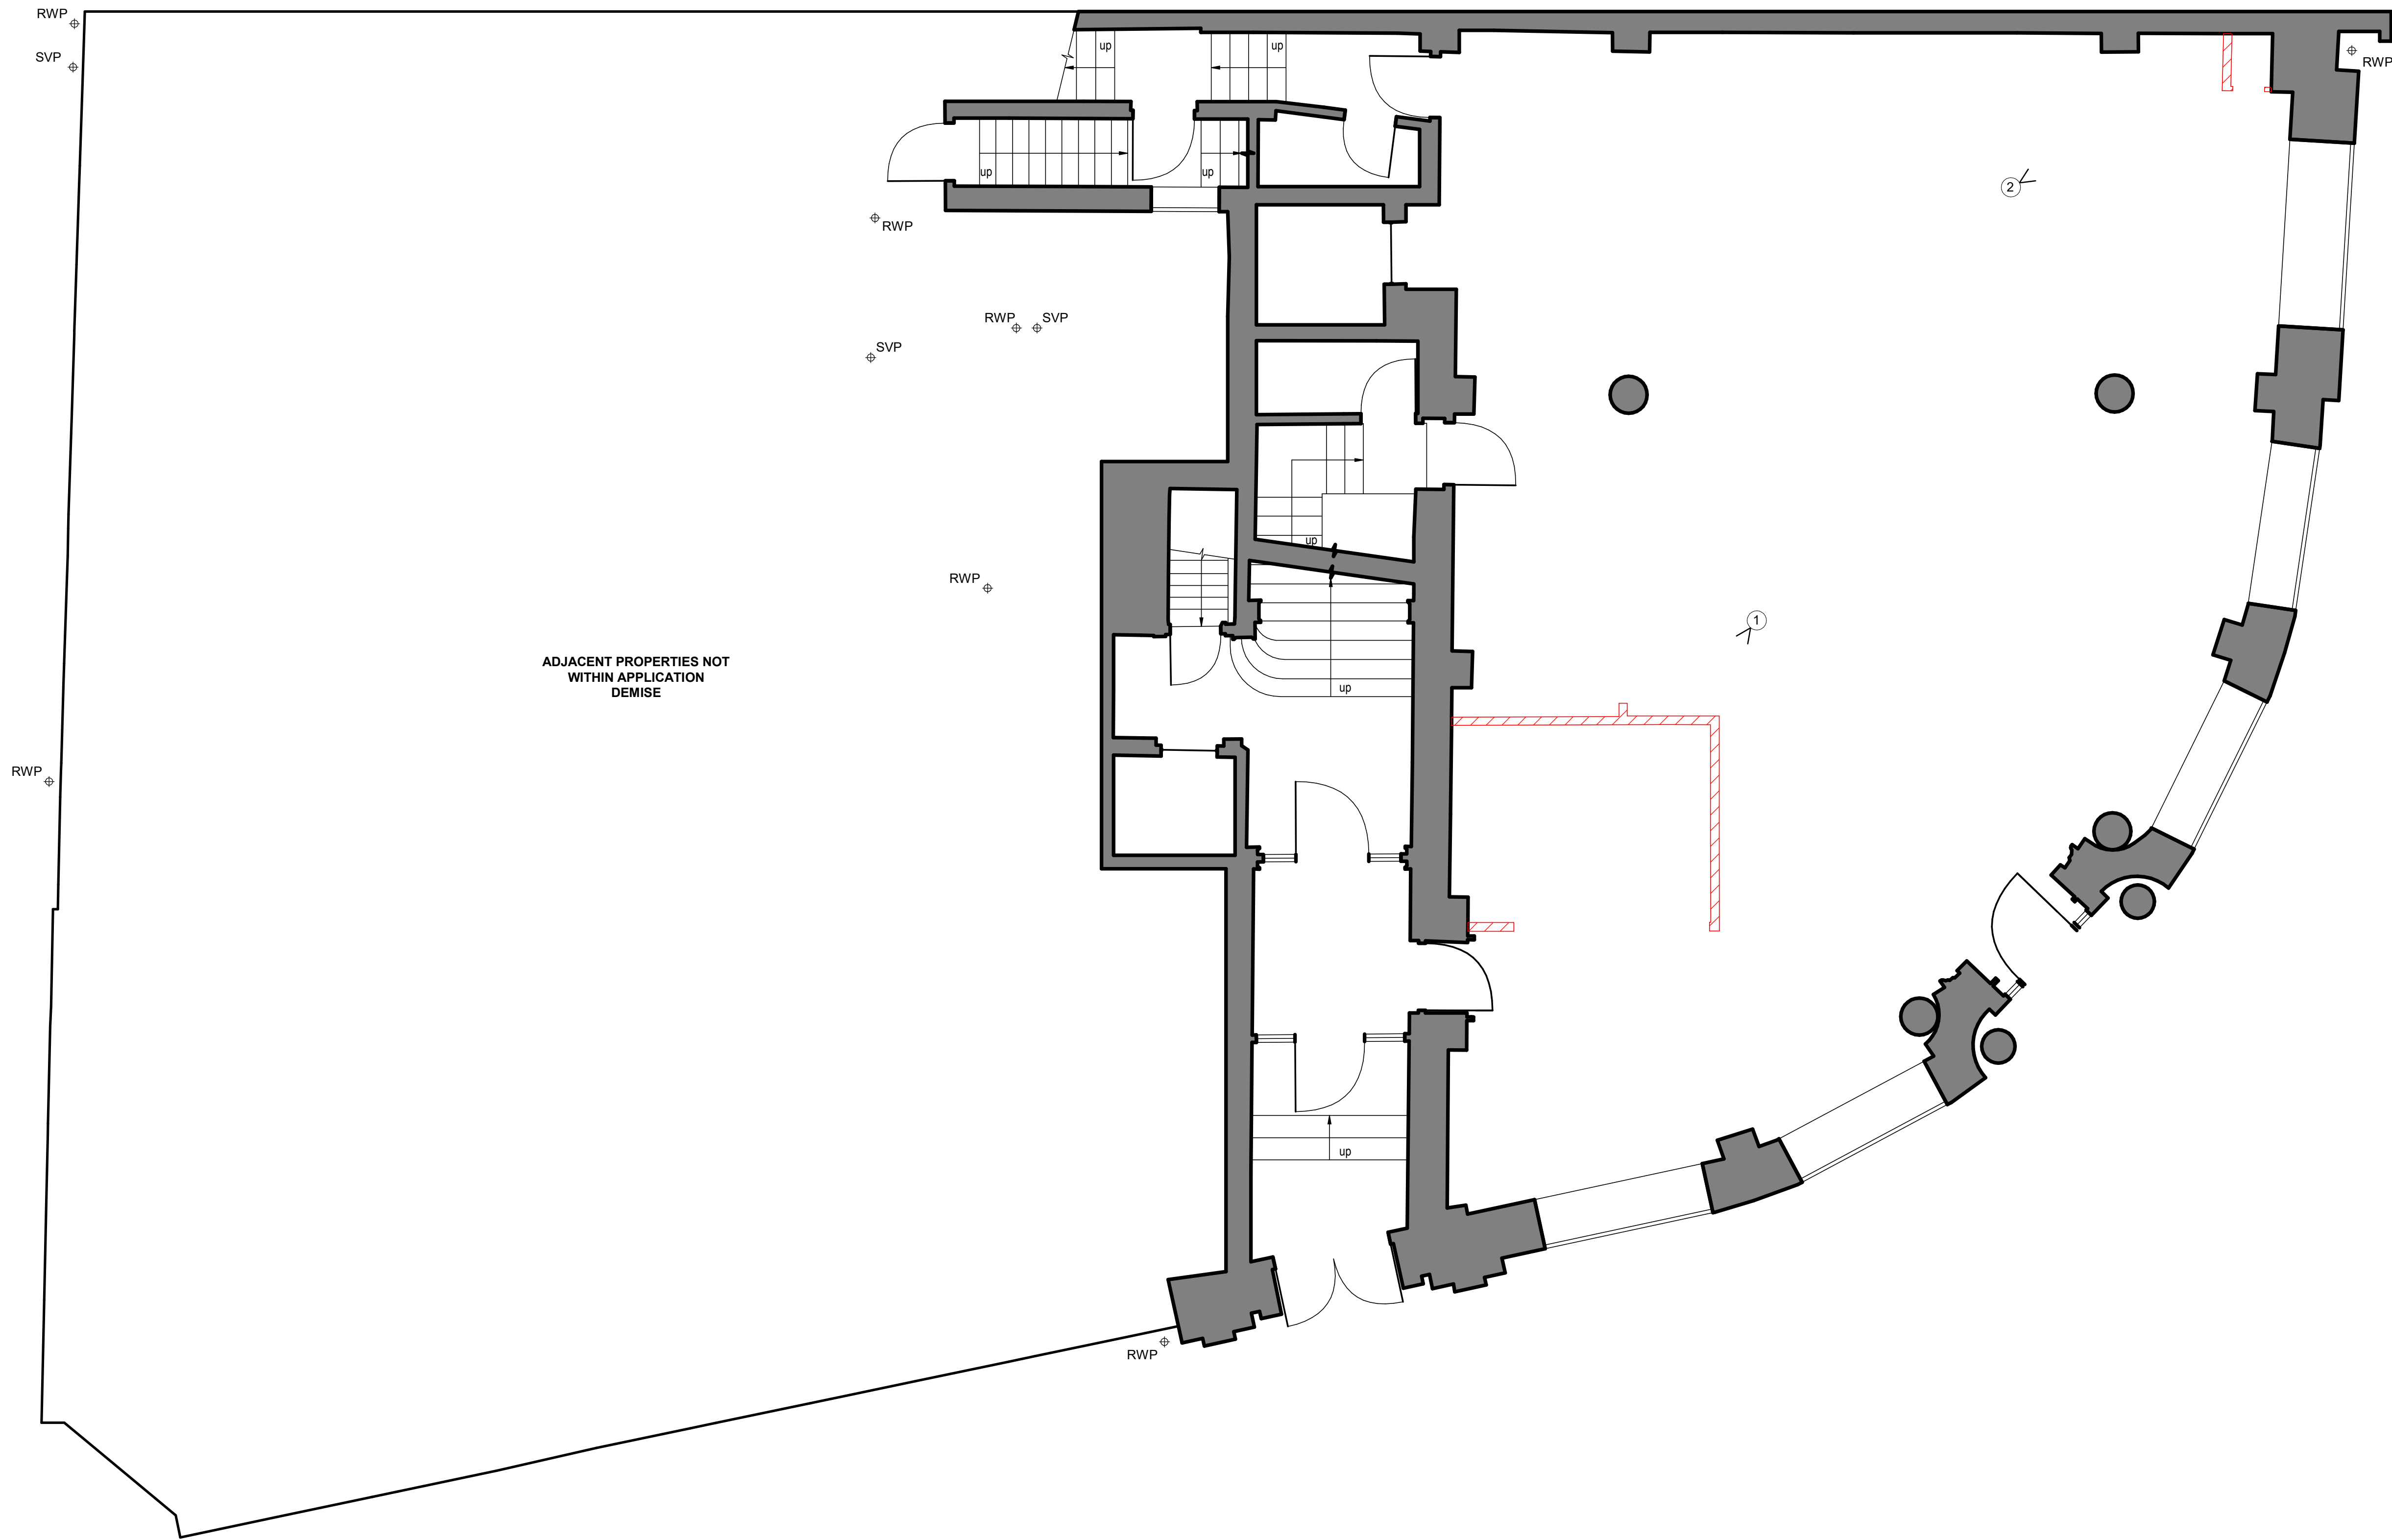

Key

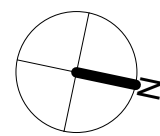

Existing Building Elements




Demolished Building Elements



Existing Elements Moved / Repurposed

DEMOLITION NOTES - GROUND FLOOR

 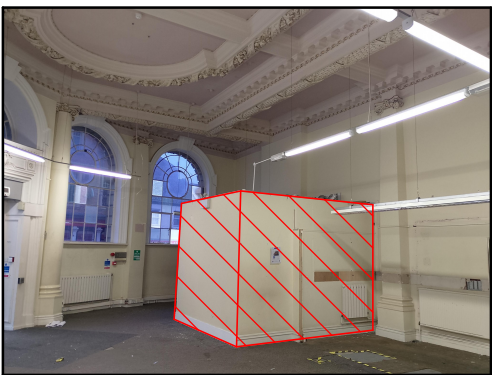


① Partition walls of office cubicle to be removed, isolating and removing electrical, mechanical and plumbing fixtures. Disturbed surfaces to be made good.



② Goods lift and plasterboard encasement o be removed, isolating and removing electrical and mechanical fixtures. Disturbed surfaces to be made good. Particular care to be taken when removing elements near coving. Coving and skirting to be repaired / replaced in corner where currently missing.

P1	Planning Submission	21.07.25
Revision:	Description:	Date:
Project:	Originator:	Volume:
24.044	CA	XX
		00
		DR
		A
		00_002
		P1
Project:	Former Barclays Bank 1 King Street South Shields NE33 1DA	CAL Project No: 24.044
Client:	Regal Bifrons Properties Ltd	
Drawing:	Ground Floor Demolition Plan	
Scale:	1 : 50	Print Size: A1
		Drawn By: RH
		Chkd By: CK



Map House,
3 George Stephenson Court,
Preston Farm,
Stockton on Tees,
TS18 3TG

t : 01642 062521
e : info@createarchitecture.co.uk

Architectural Consultants | Land & Property Consultants |
a Private Limited Company - reg. no. 08859320

CIAT

affiliate group
body corporate