


Rev:	Description:	By:	Date:
------	--------------	-----	-------



octopusenergy
services

Approved by:

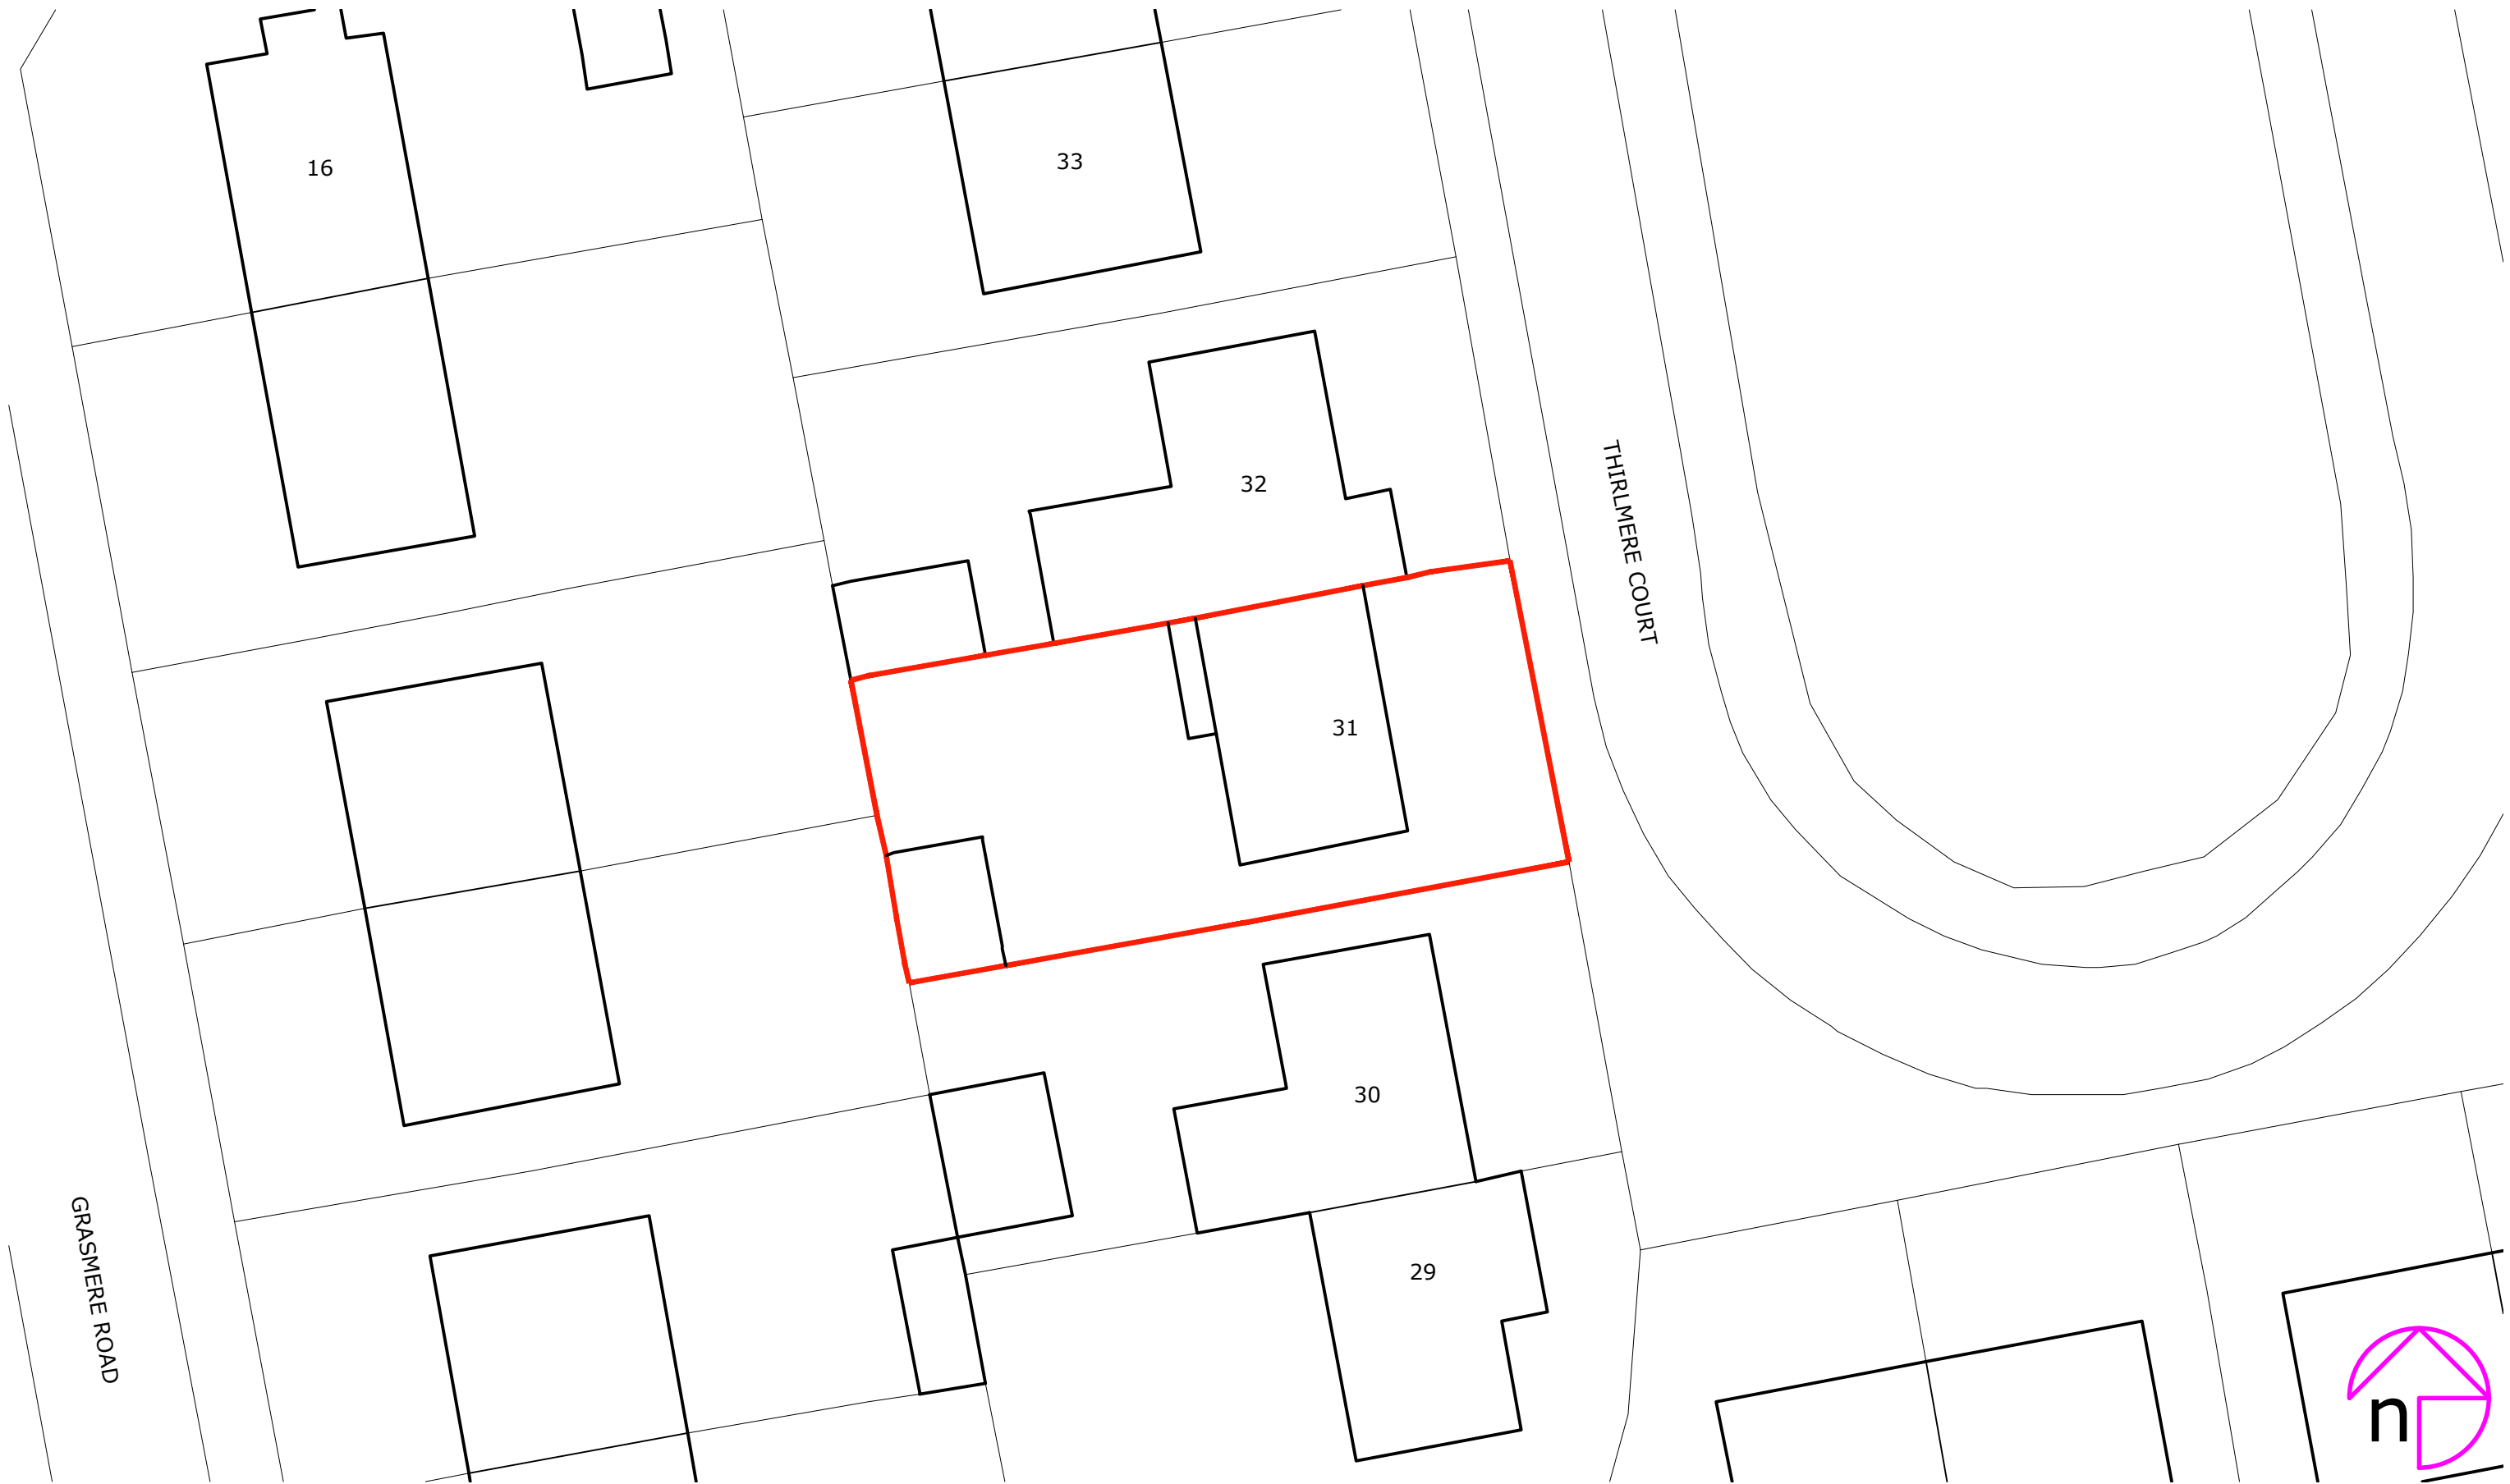

Client/Project: Ryan Shilling, 31, Thirlmere Court, Hebburn, NE31 2RP	Project status: PLANNING (installation of air source heat pump)
	Drawing title: Site plan as existing

Scale: 1:200	Paper Size: A3	Drawn: A Walton	Checked: ...
Project ID: J-4A6FF576	Drawing No: 01	Revision:	Date: 05.05.2026