


Rev:	Description:	By:	Date:
------	--------------	-----	-------

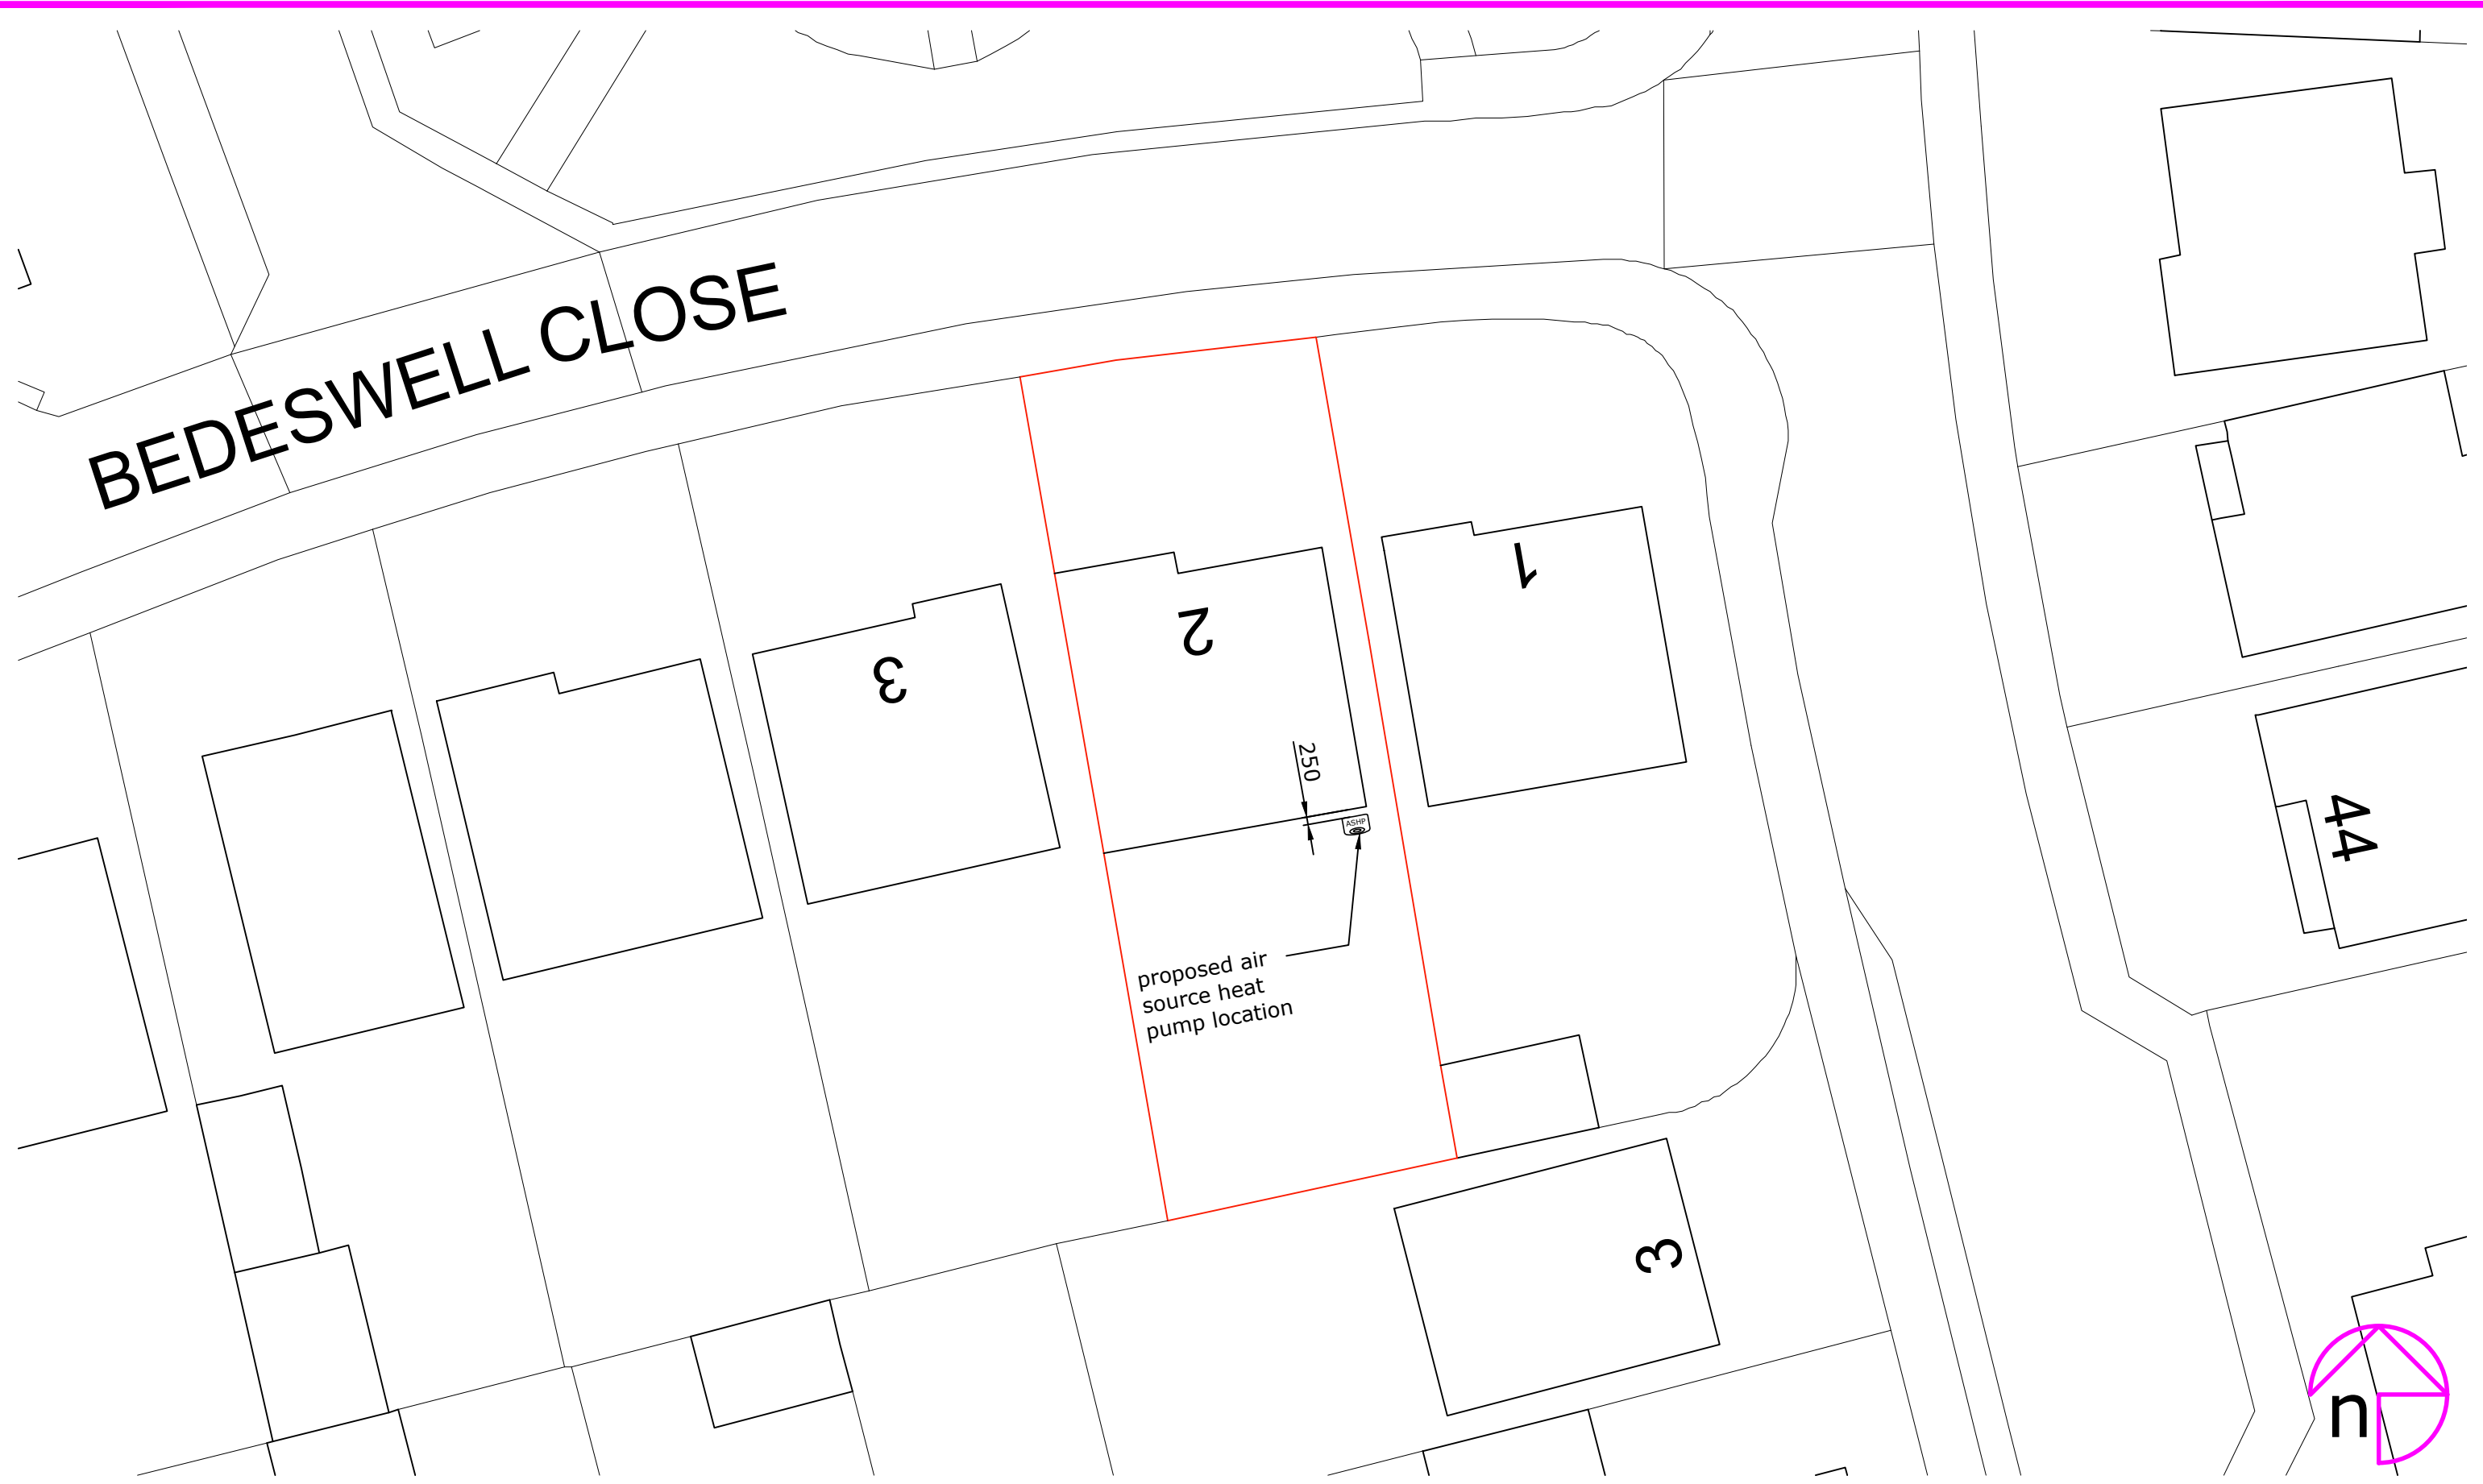

octopusenergy
services

Approved by:



Client/Project:
Alan Riddell
2 BEDSWELL CLOSE
Newcastle Upon-Tyne NE31 2GB

Project status:
PLANNING (installation of air source heat pump)
Drawing title:
Site plan as proposed

Scale: 1:200	Paper Size: A3	Drawn: O Sage	Checked: E.H
Project ID: J-306FCAEA	Drawing No: 02	Revision:	Date: 07.07.26